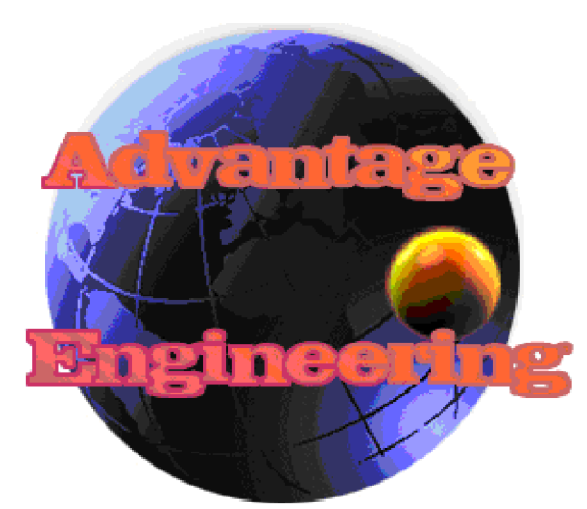
 



REVISIONS			
SYM.	DATE	BY	DESCRIPTION


INDEX

<u>COVER PAGES</u>	<u>DESCRIPTION</u>	<u>PAGE NO.</u>
COVER	TITLE PAGE	AB-C000
INDEX	INDEX & LEGEND	AB-C001
<u>PLUMBING</u>	<u>DESCRIPTION</u>	<u>PAGE NO.</u>
PLUMBING LAYOUT	PLAN VIEW OF PLUMBING SYSTEM	AB-P100
PLUMBING DETAILS	ENLARGED PLAN VIEWS OF PLUMBING FOR CLARITY	AB-P101
PLUMBING ISOMETRIC	PLUMBING RISER ISOMETRIC & DETAILS (SOUTHWEST ISOMETRIC)	AB-P102
PLUMBING ISOMETRIC	PLUMBING RISER ISOMETRIC & DETAILS (SOUTHEAST ISOMETRIC)	AB-P103

NOTES		PROFESSIONAL ENGINEER STAMP:	CLIENT:	TOLERANCES UNLESS NOTED DECIMAL ± 0.125" FRACTIONAL ± 2" ANGULAR ± 5°	DRAWN	TITLE				
				ALL DIMENSIONS IN INCHES	R.A.V.	INDEX PAGE				
				THIRD ANGLE PROJECTION USED 	DATE	SHEET SIZE DRAWING NO. SHEET NO. CHECKED BY				
				PROPRIETARY – The material on this print is proprietary and the property of Advantage Engineering, not to be reproduced, published, or disclosed to others without prior written authorization from Advantage Engineering.	SCALE	D	AB-C001			
					NTS	 Advantage Engineering TEL: 518-320-2501 P.O. BOX 1042, BALLSTON LAKE, N.Y. 12019 FAX: 518-884-0976 EMAIL: AdvantageEng@nycap.rr.com				

REVISIONS			
SYM.	DATE	BY	DESCRIPTION

FOR DETAILS REFER 2/AB-P101

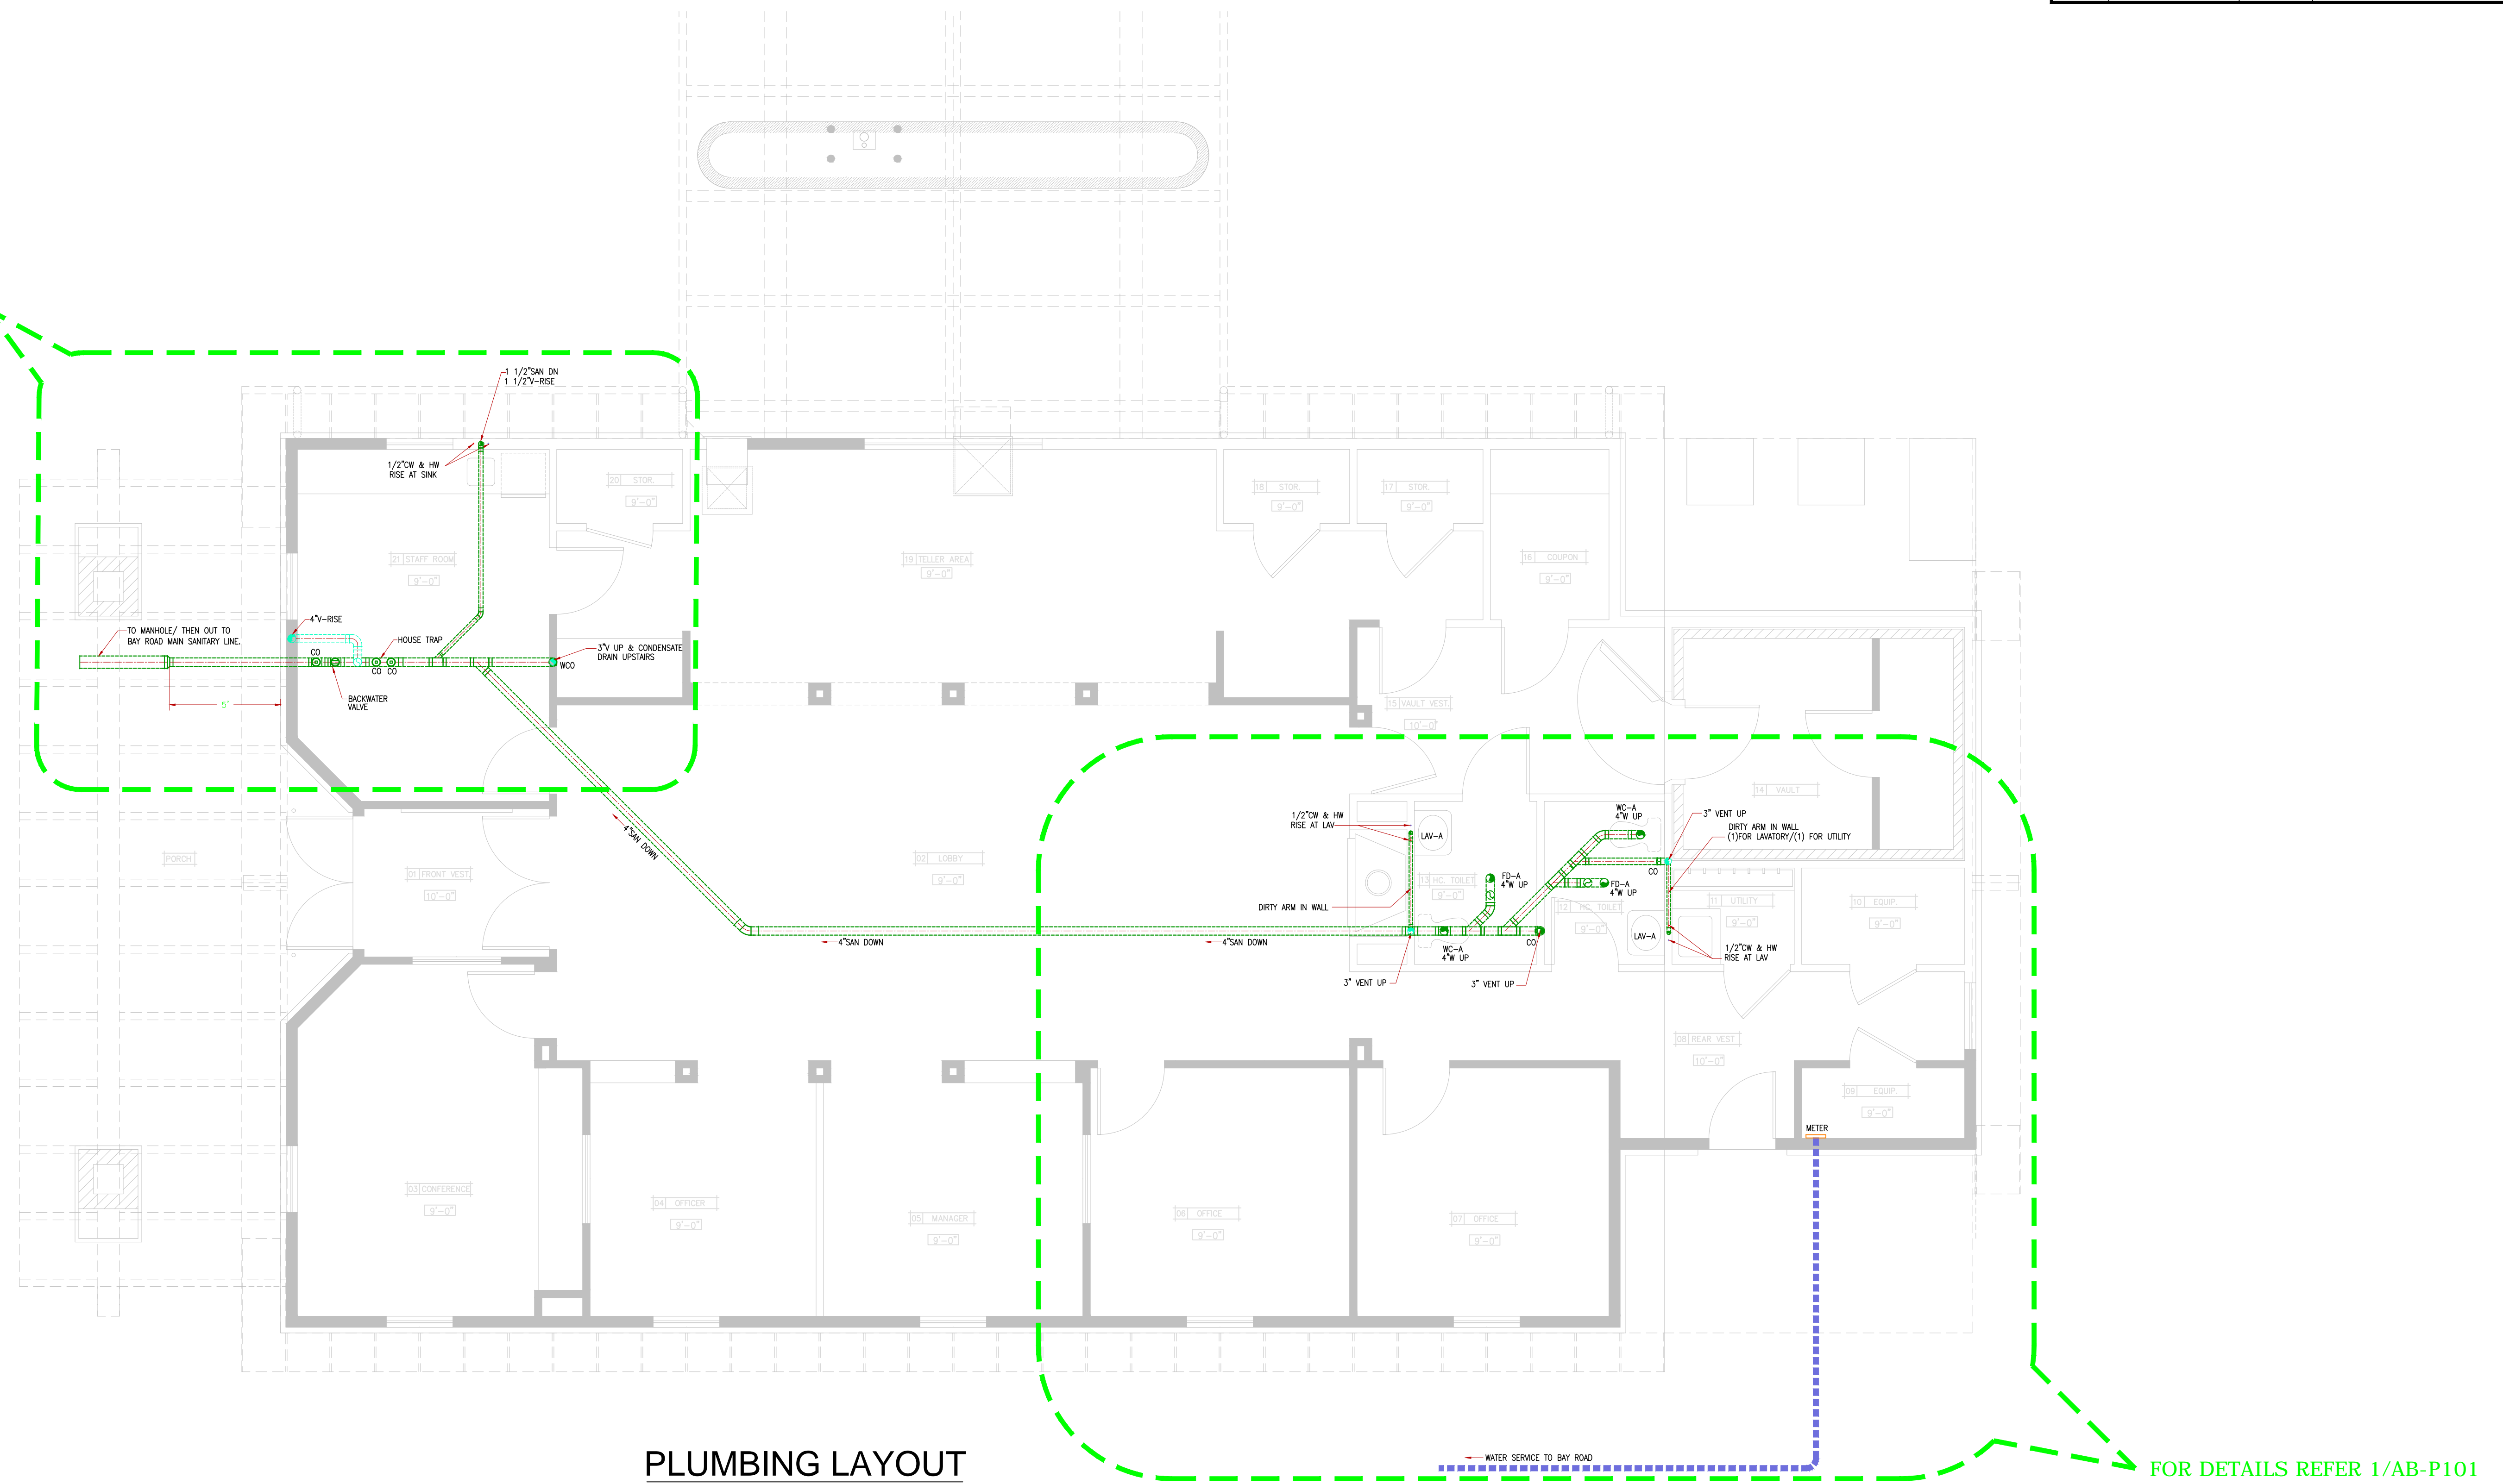

PLUMBING LAYOUT

SCALE: 1/4"=1'

FOR DETAILS REFER 1/AB-P101

NOTES

- THE PURPOSE OF THIS DRAWING IS TO SHOW THE INSTALLATION OF PLUMBING.
- NO INVESTIGATION HAS BEEN MADE WITH REGARD TO CONFORMANCE WITH ANY OTHER CODES OR STANDARDS.

LEGEND

SAN — SANITARY PIPE
 V — VENT PIPE

PROFESSIONAL ENGINEER STAMP:

CLIENT:

TOLERANCES UNLESS NOTED
 DECIMAL ± 0.125"
 FRACTIONAL ± 2"
 ANGULAR ± 5"

ALL DIMENSIONS IN INCHES

THIRD ANGLE PROJECTION USED

PROPRIETARY — The material on this print is proprietary and the property of Advantage Engineering, not to be reproduced, published, or disclosed to others without prior written authorization from Advantage Engineering.

DRAWN
 R.A.V.
 DATE
 SCALE
 1/4"=1'


TITLE

PLUMBING LAYOUT


SHEET SIZE	DRAWING NO.	SHEET NO.	CHECKED BY
D	AB-P100		

Advantage Engineering
 P.O. BOX 1042, BALLSTON LAKE, N.Y. 12019
 TEL: 518-320-2501
 FAX: 518-884-0976
 EMAIL: AdvantageEng@nycap.rr.com

REVISIONS			
SYM.	DATE	BY	DESCRIPTION

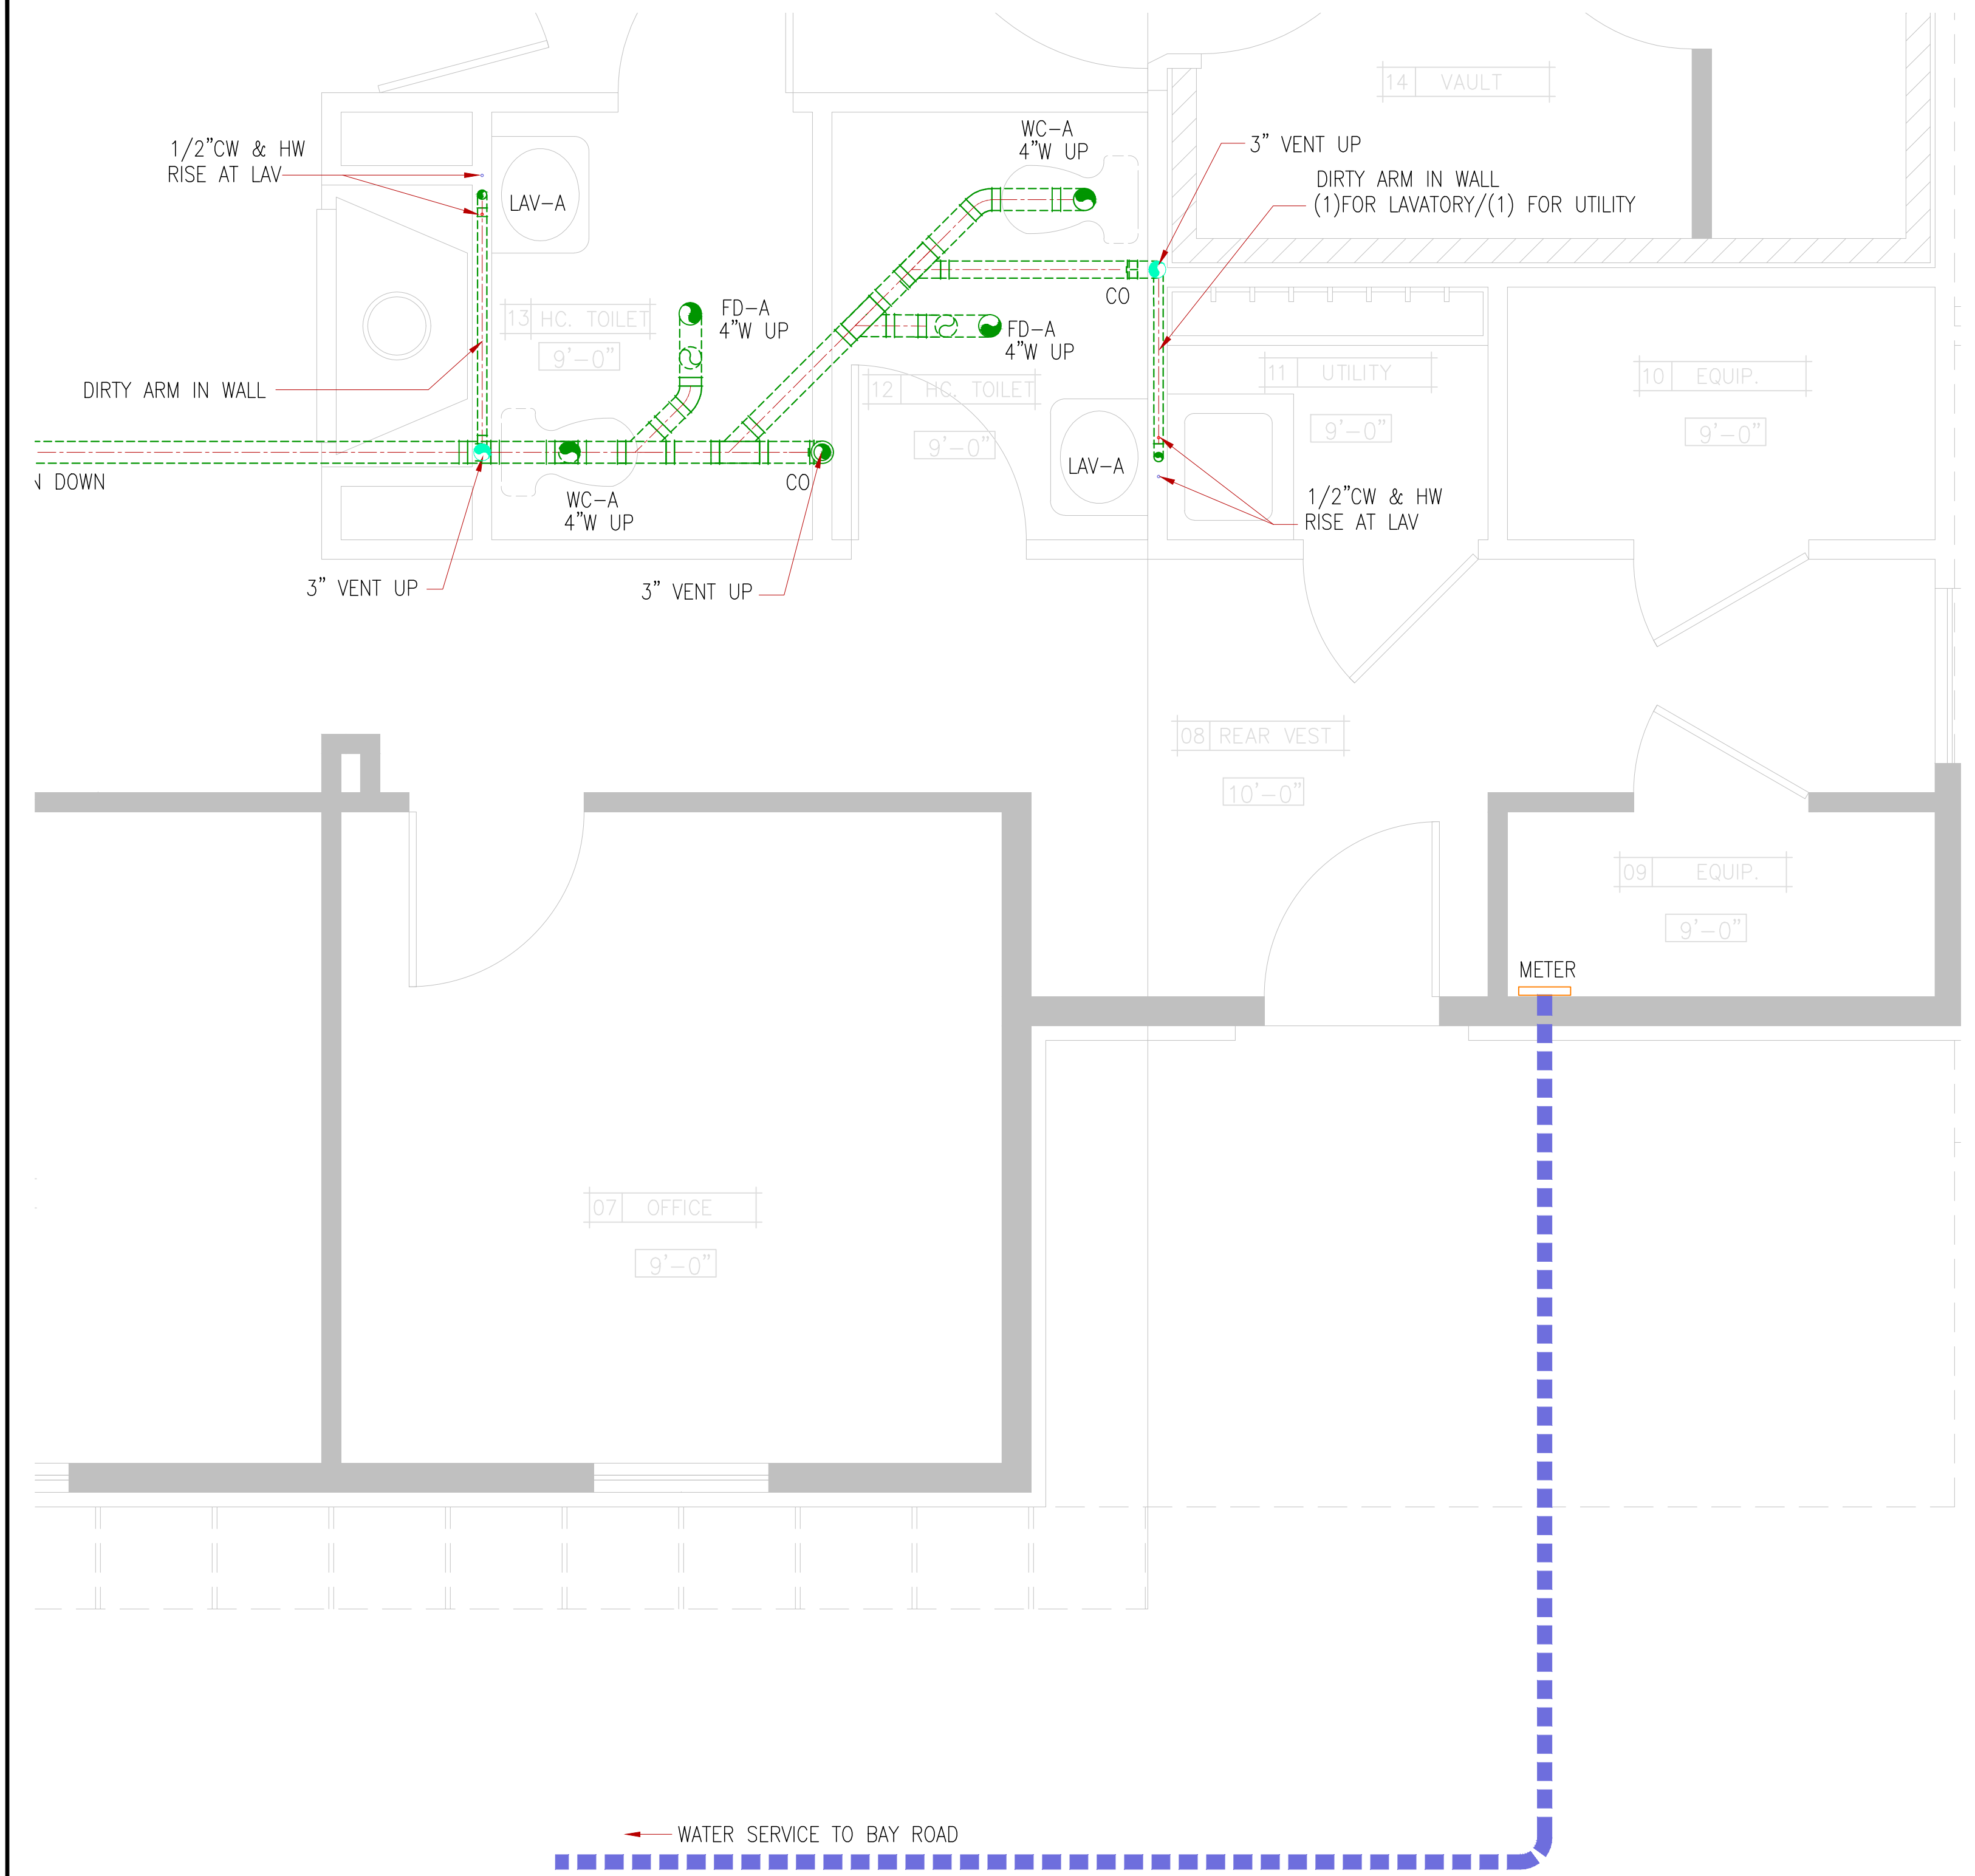

1 ENLARGED PLUMBING PLAN
SCALE: 1/2"=1'

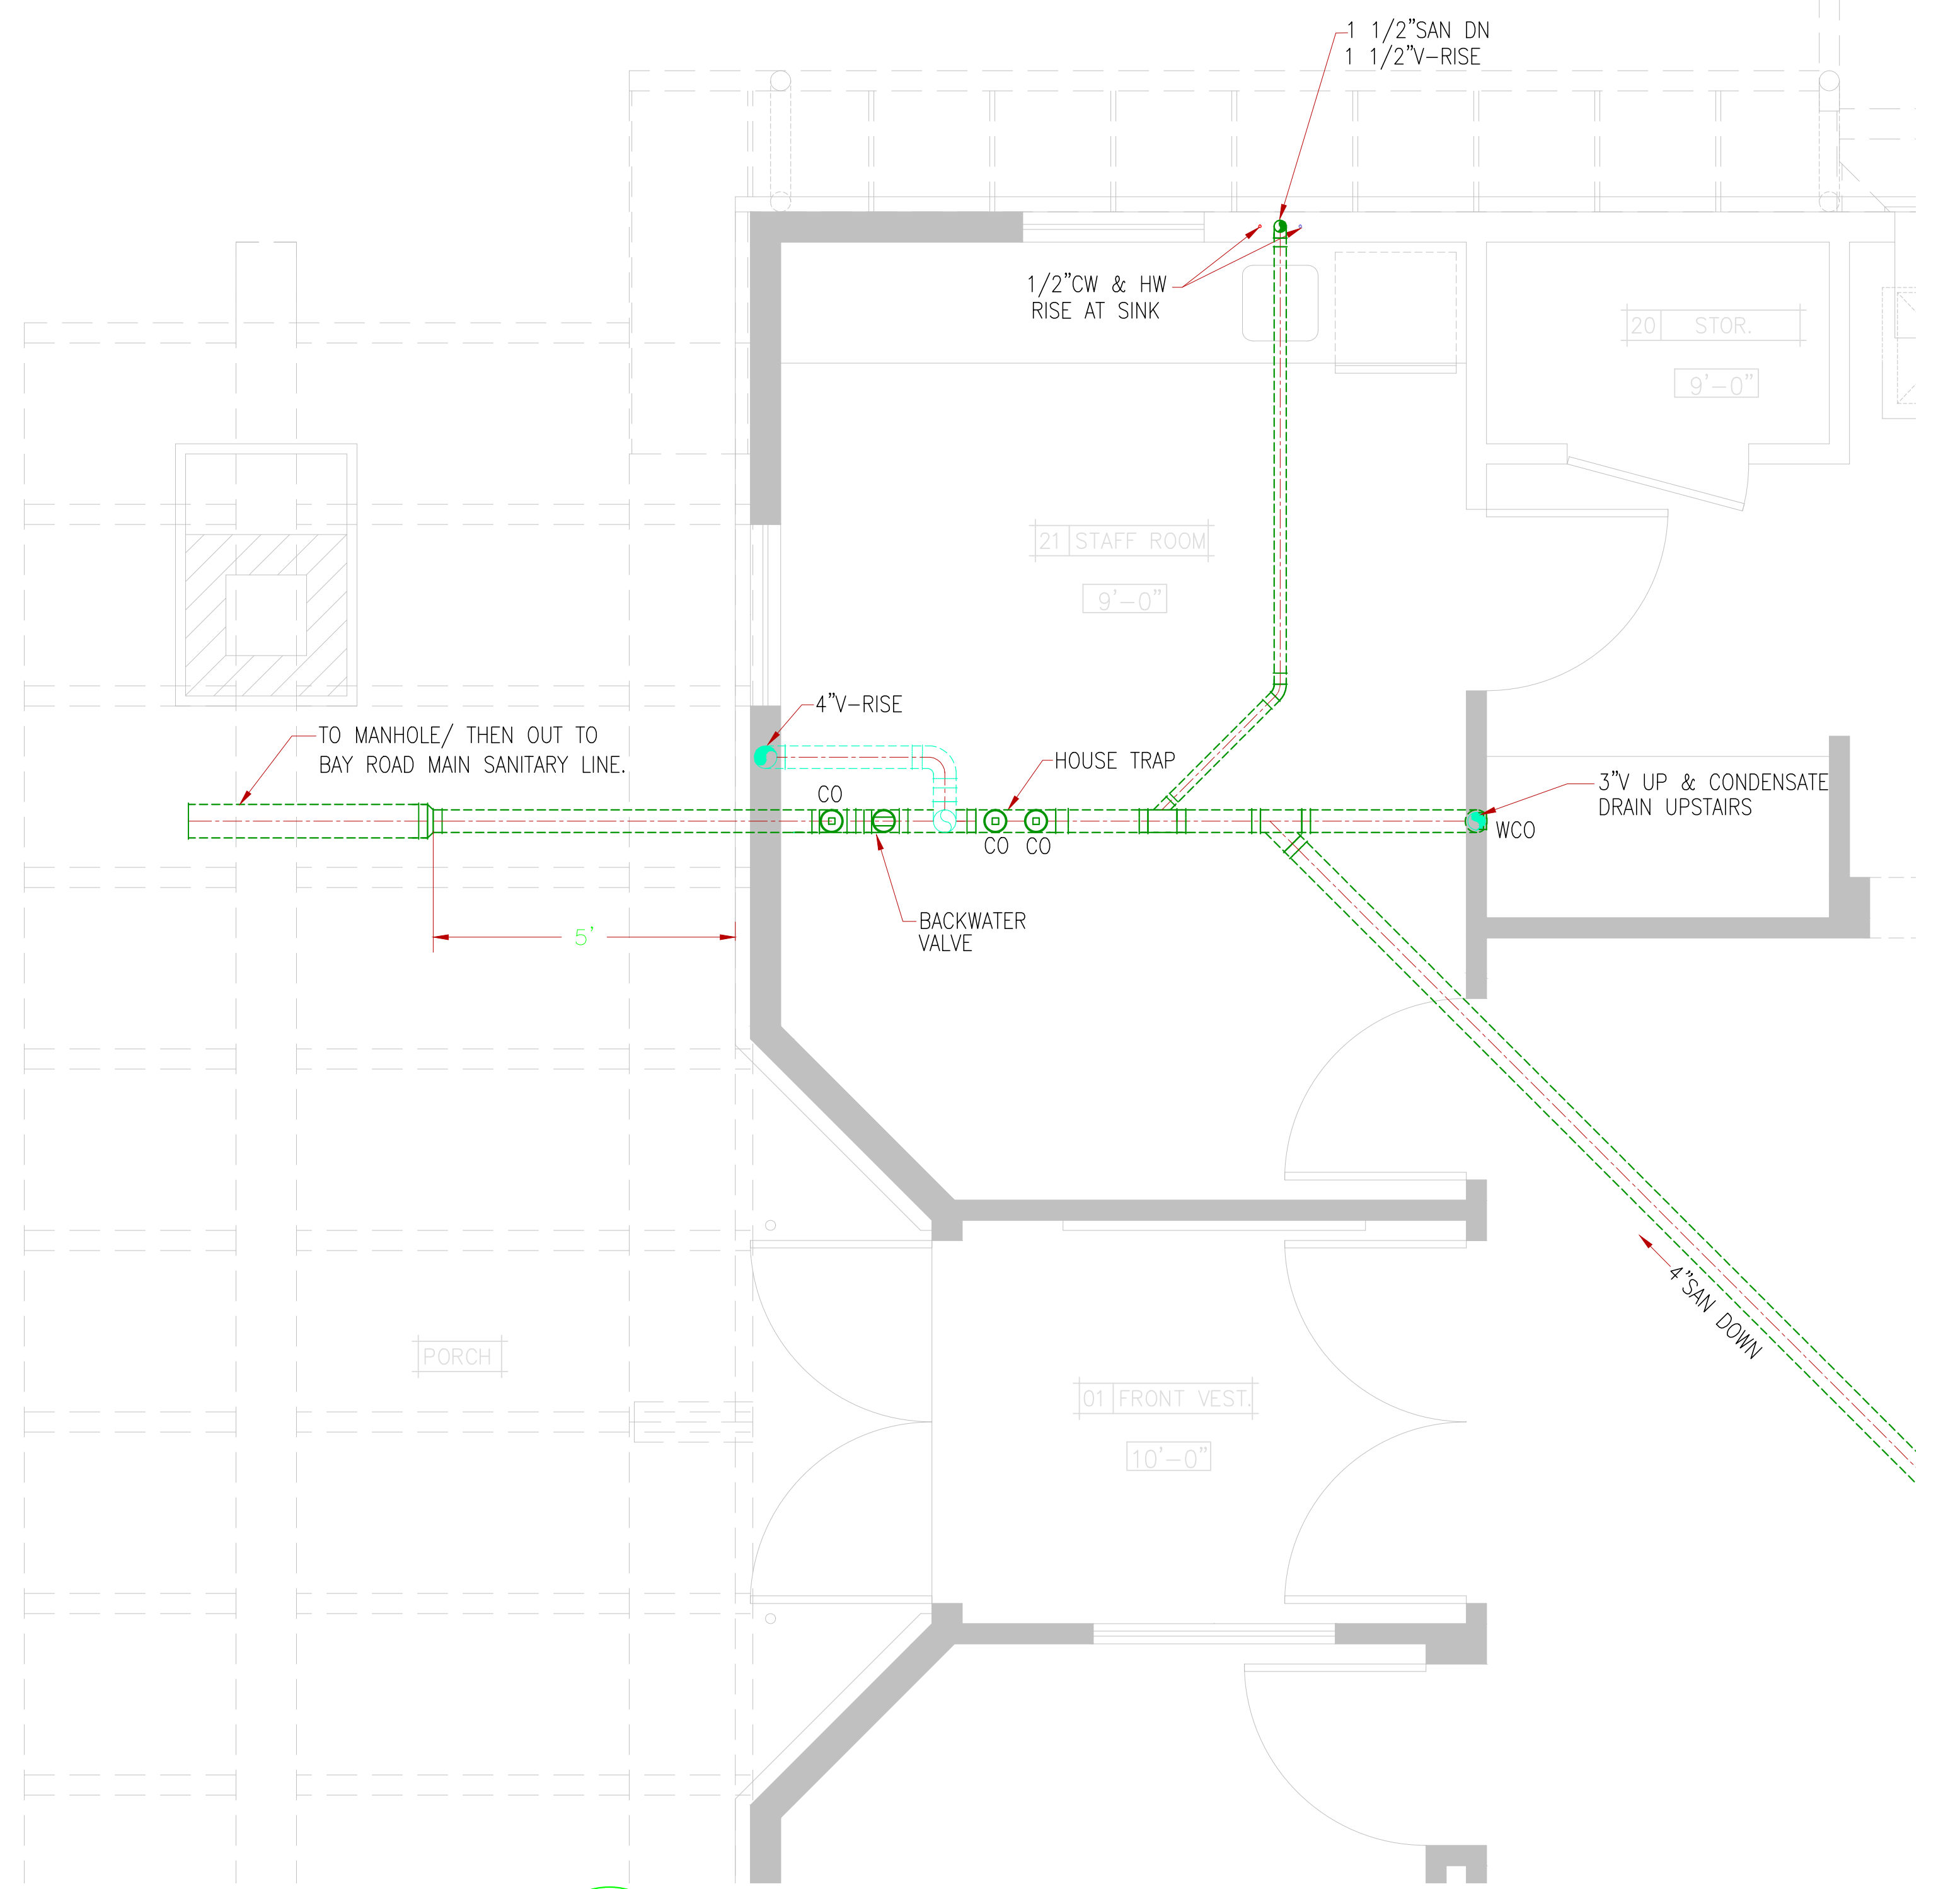

2 ENLARGED PLUMBING PLAN
SCALE: 1/2"=1'

NOTES

- THE PURPOSE OF THIS DRAWING IS TO SHOW THE INSTALLATION OF PLUMBING.
- NO INVESTIGATION HAS BEEN MADE WITH REGARD TO CONFORMANCE WITH ANY OTHER CODES OR STANDARDS.

LEGEND

PROFESSIONAL ENGINEER STAMP:

CLIENT:

TOLERANCES UNLESS NOTED
 DECIMAL ± 0.125"
 FRACTIONAL ± 2"
 ANGULAR ± 5"

ALL DIMENSIONS IN INCHES

THIRD ANGLE PROJECTION USED

PROPRIETARY – The material on this print is proprietary and the property of Advantage Engineering, not to be reproduced, published, or disclosed to others without prior written authorization from Advantage Engineering.

DRAWN
 R.A.V.
 DATE
 SCALE
 AS SHOWN

TITLE


PLUMBING ENLARGED PLAN

SHEET SIZE	DRAWING NO.	SHEET NO.	CHECKED BY
D	AB-P101		


Advantage Engineering
 P.O. BOX 1042, BALLSTON LAKE, N.Y. 12019

TEL: 518-320-2501
 FAX: 518-884-0976
 EMAIL: AdvantageEng@nycap.rr.com

REVISIONS			
SYM.	DATE	BY	DESCRIPTION

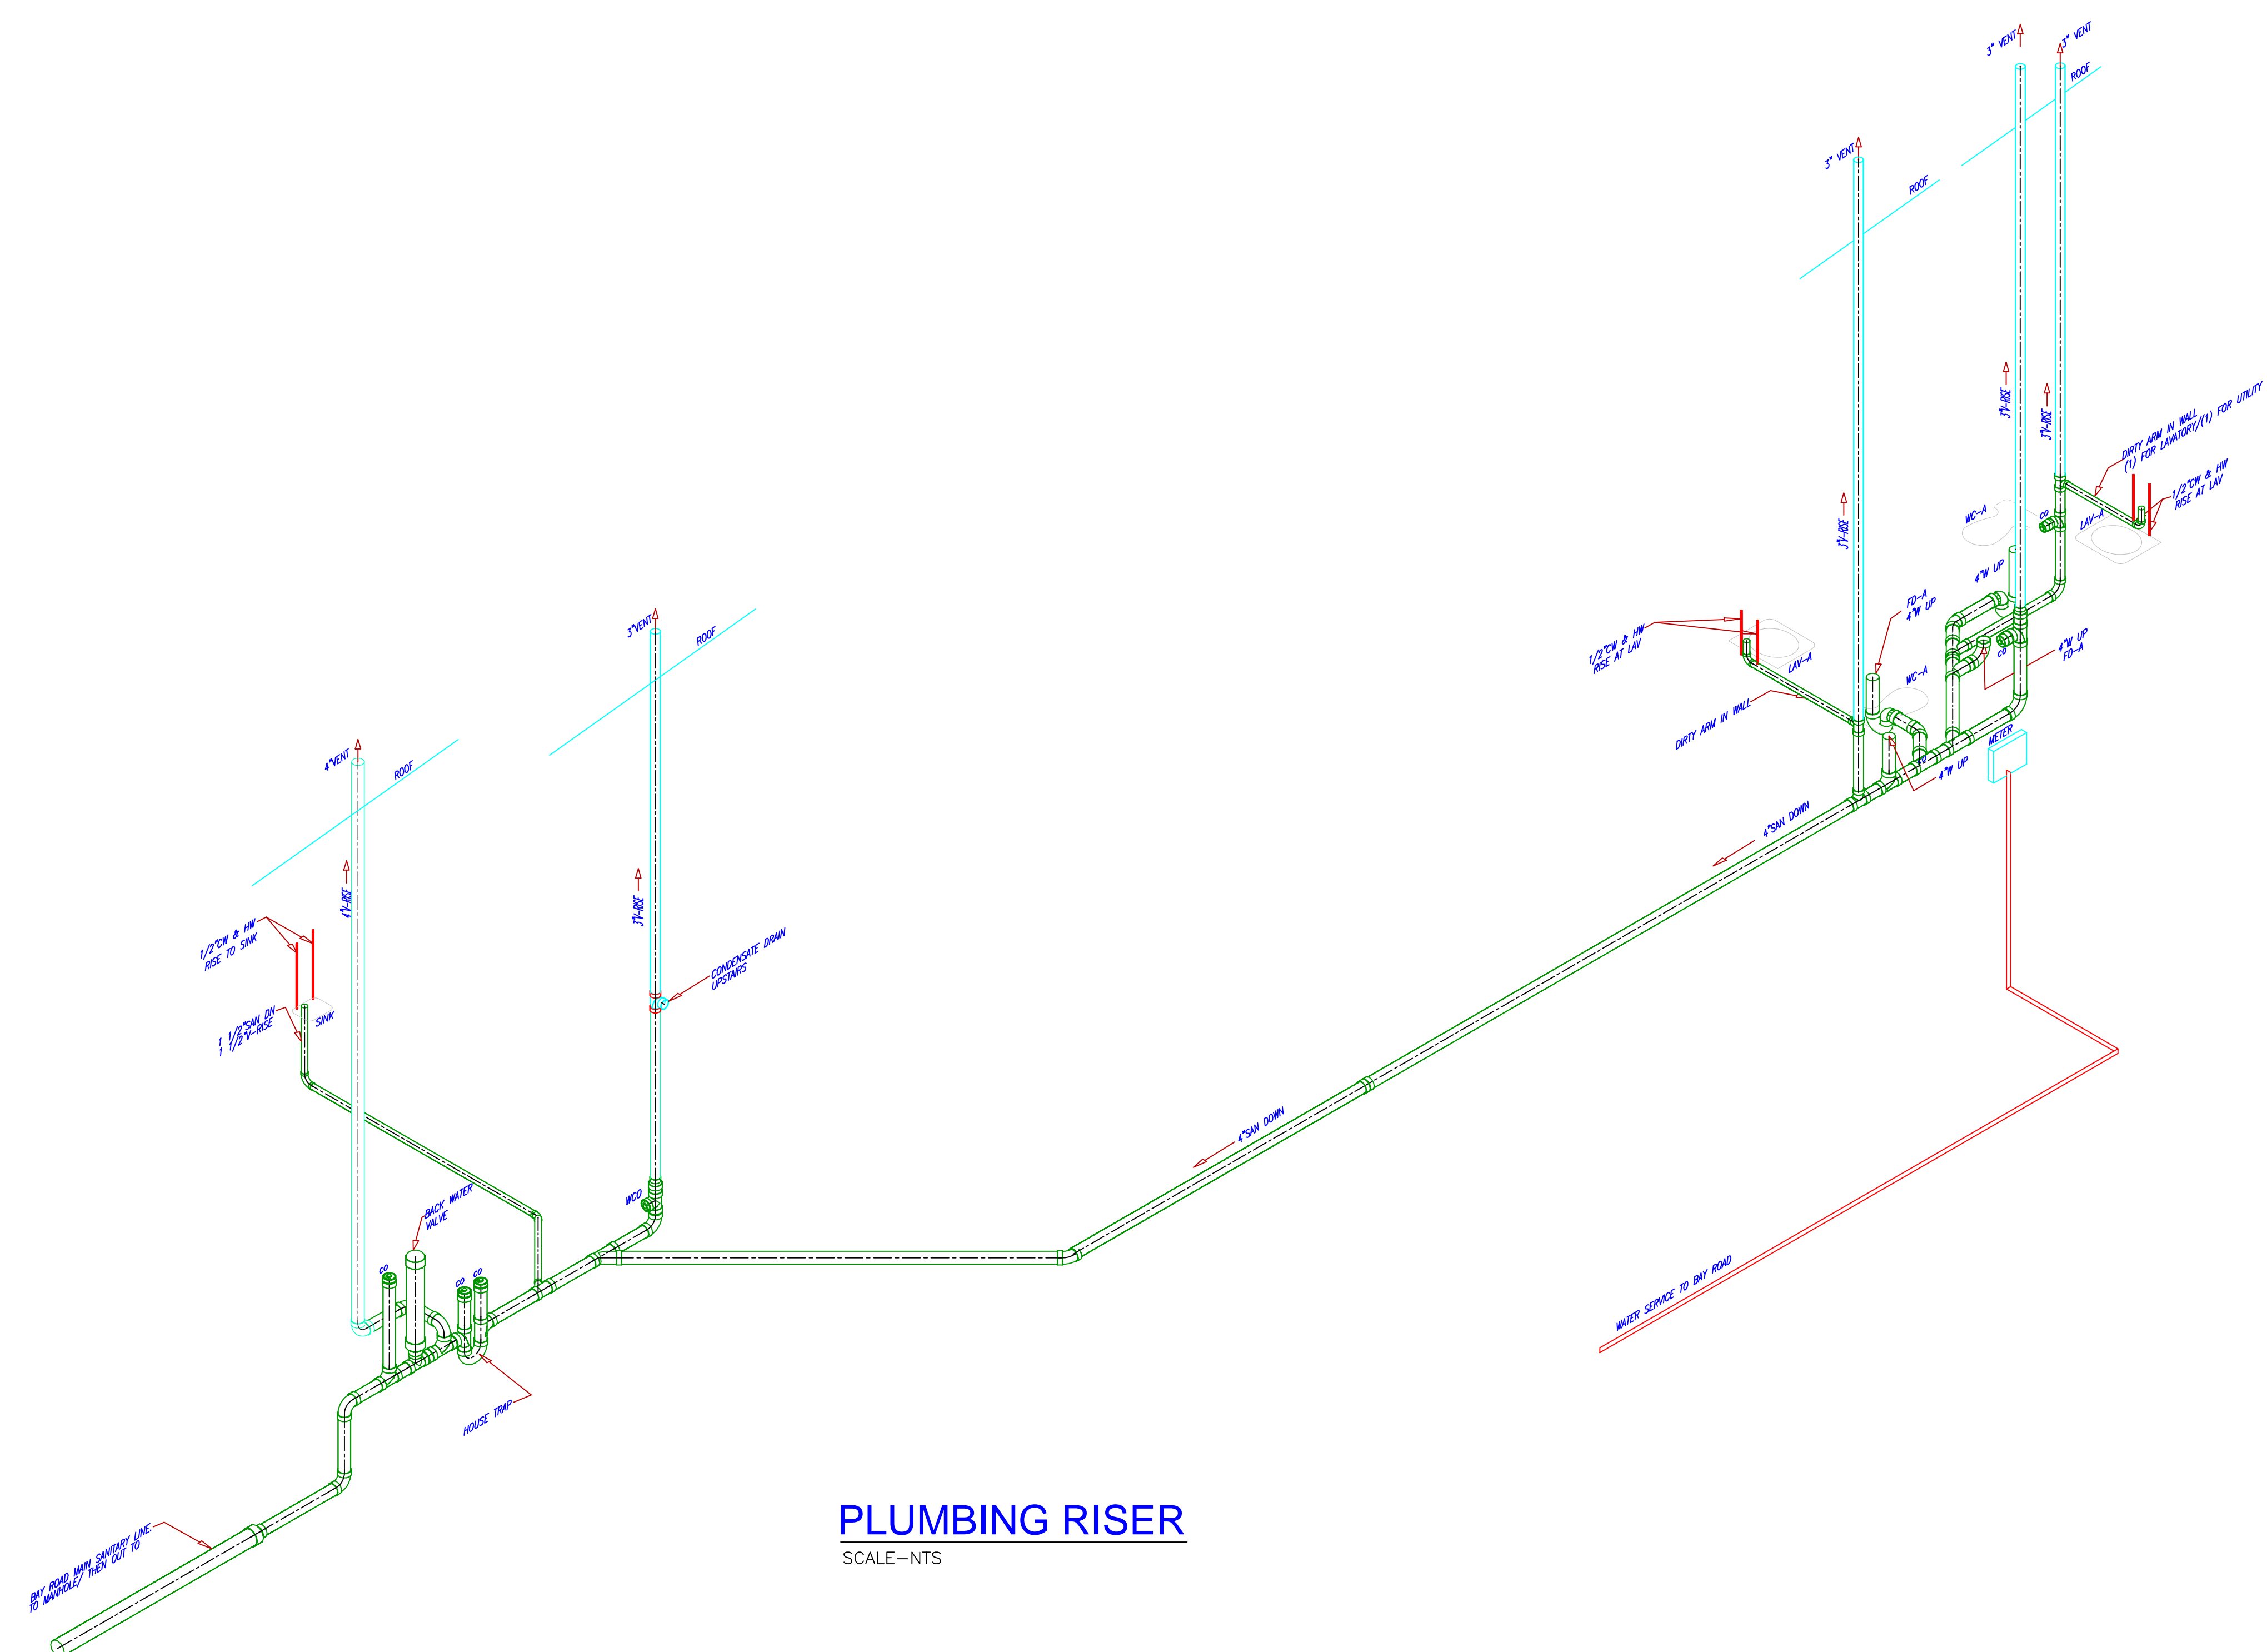

PLUMBING RISER
SCALE-NTS

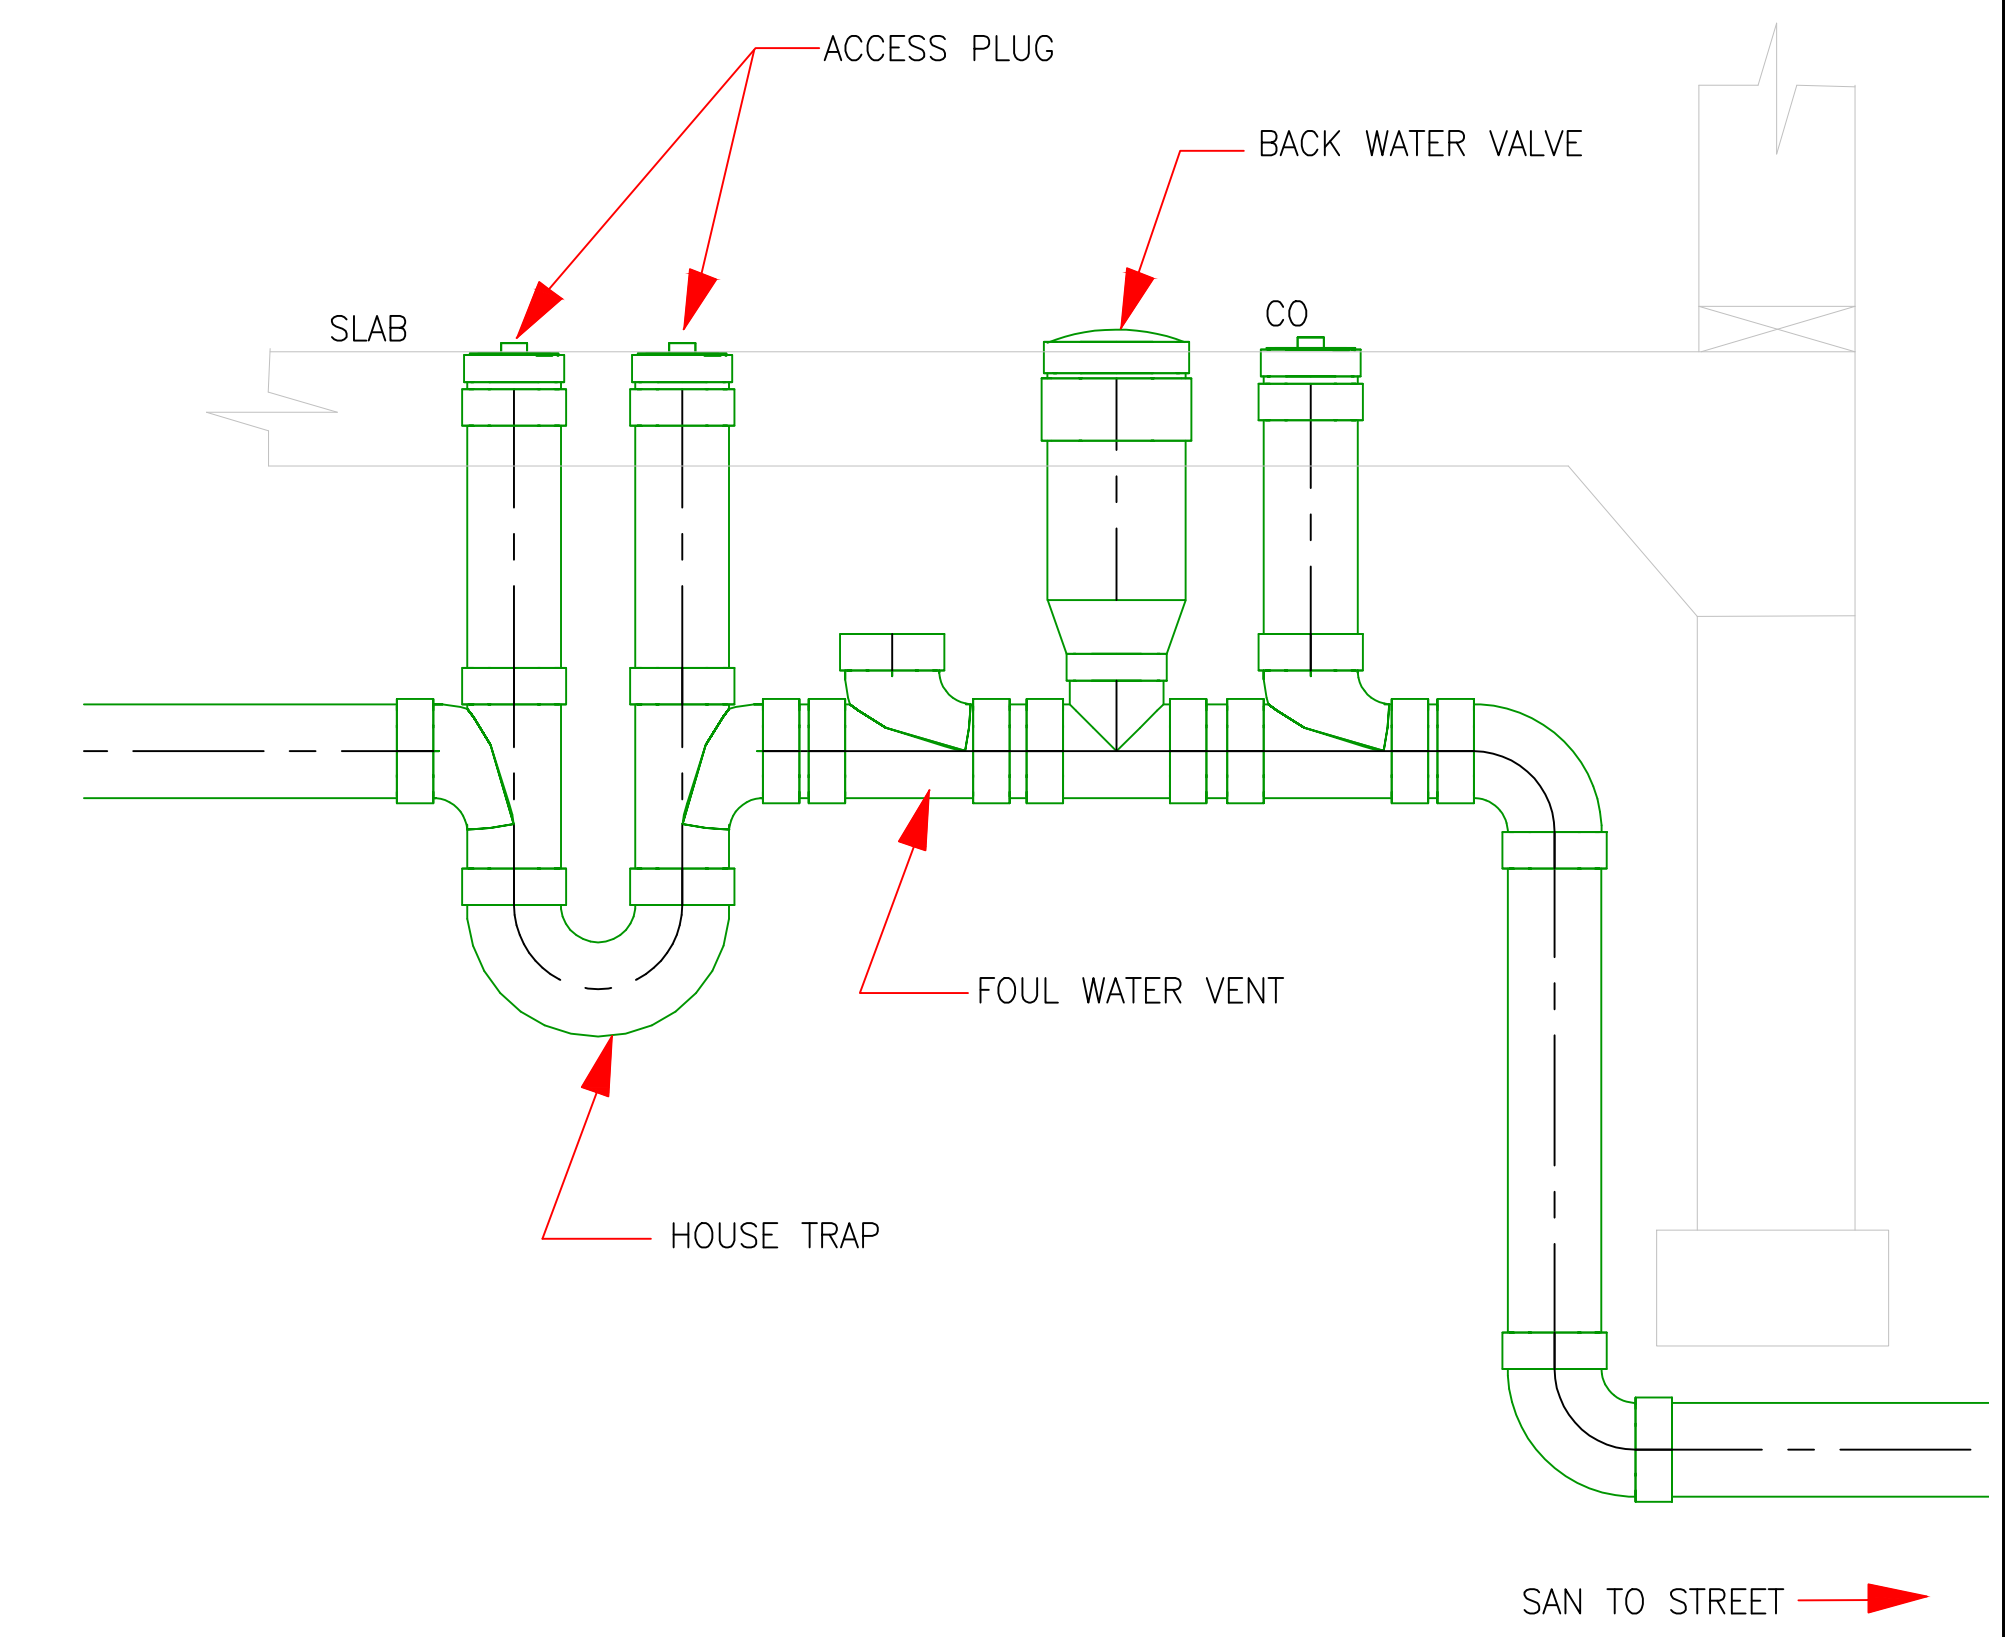

HOUSE TRAP DETAIL
SCALE-NTS

NOTES	1. -
	2. -
	3. -
	4. -
	5. -



LEGEND	PROFESSIONAL ENGINEER STAMP:

CLIENT:	
---------	--

TOLERANCES UNLESS NOTED	
DECIMAL	± 0.125"
FRACTIONAL	± 2"
ANGULAR	± 5°
ALL DIMENSIONS IN INCHES	
THIRD ANGLE PROJECTION USED	
PROPRIETARY – The material on this print is proprietary and the property of Advantage Engineering, not to be reproduced, published, or disclosed to others without prior written authorization from Advantage Engineering.	

DRAWN	TITLE			
R.A.V.	PLUMBING SW ISOMETRIC & DETAILS			
DATE				
SCALE	SHEET SIZE	DRAWING NO.	SHEET NO.	CHECKED BY
AS SHOWN	D	AB-P102		
		Advantage Engineering P.O. BOX 1042, BALLSTON LAKE, N.Y. 12019		TEL: 518-320-2501 FAX: 518-884-0976 EMAIL: AdvantageEng@nycap.rr.com

REVISIONS			
SYM.	DATE	BY	DESCRIPTION

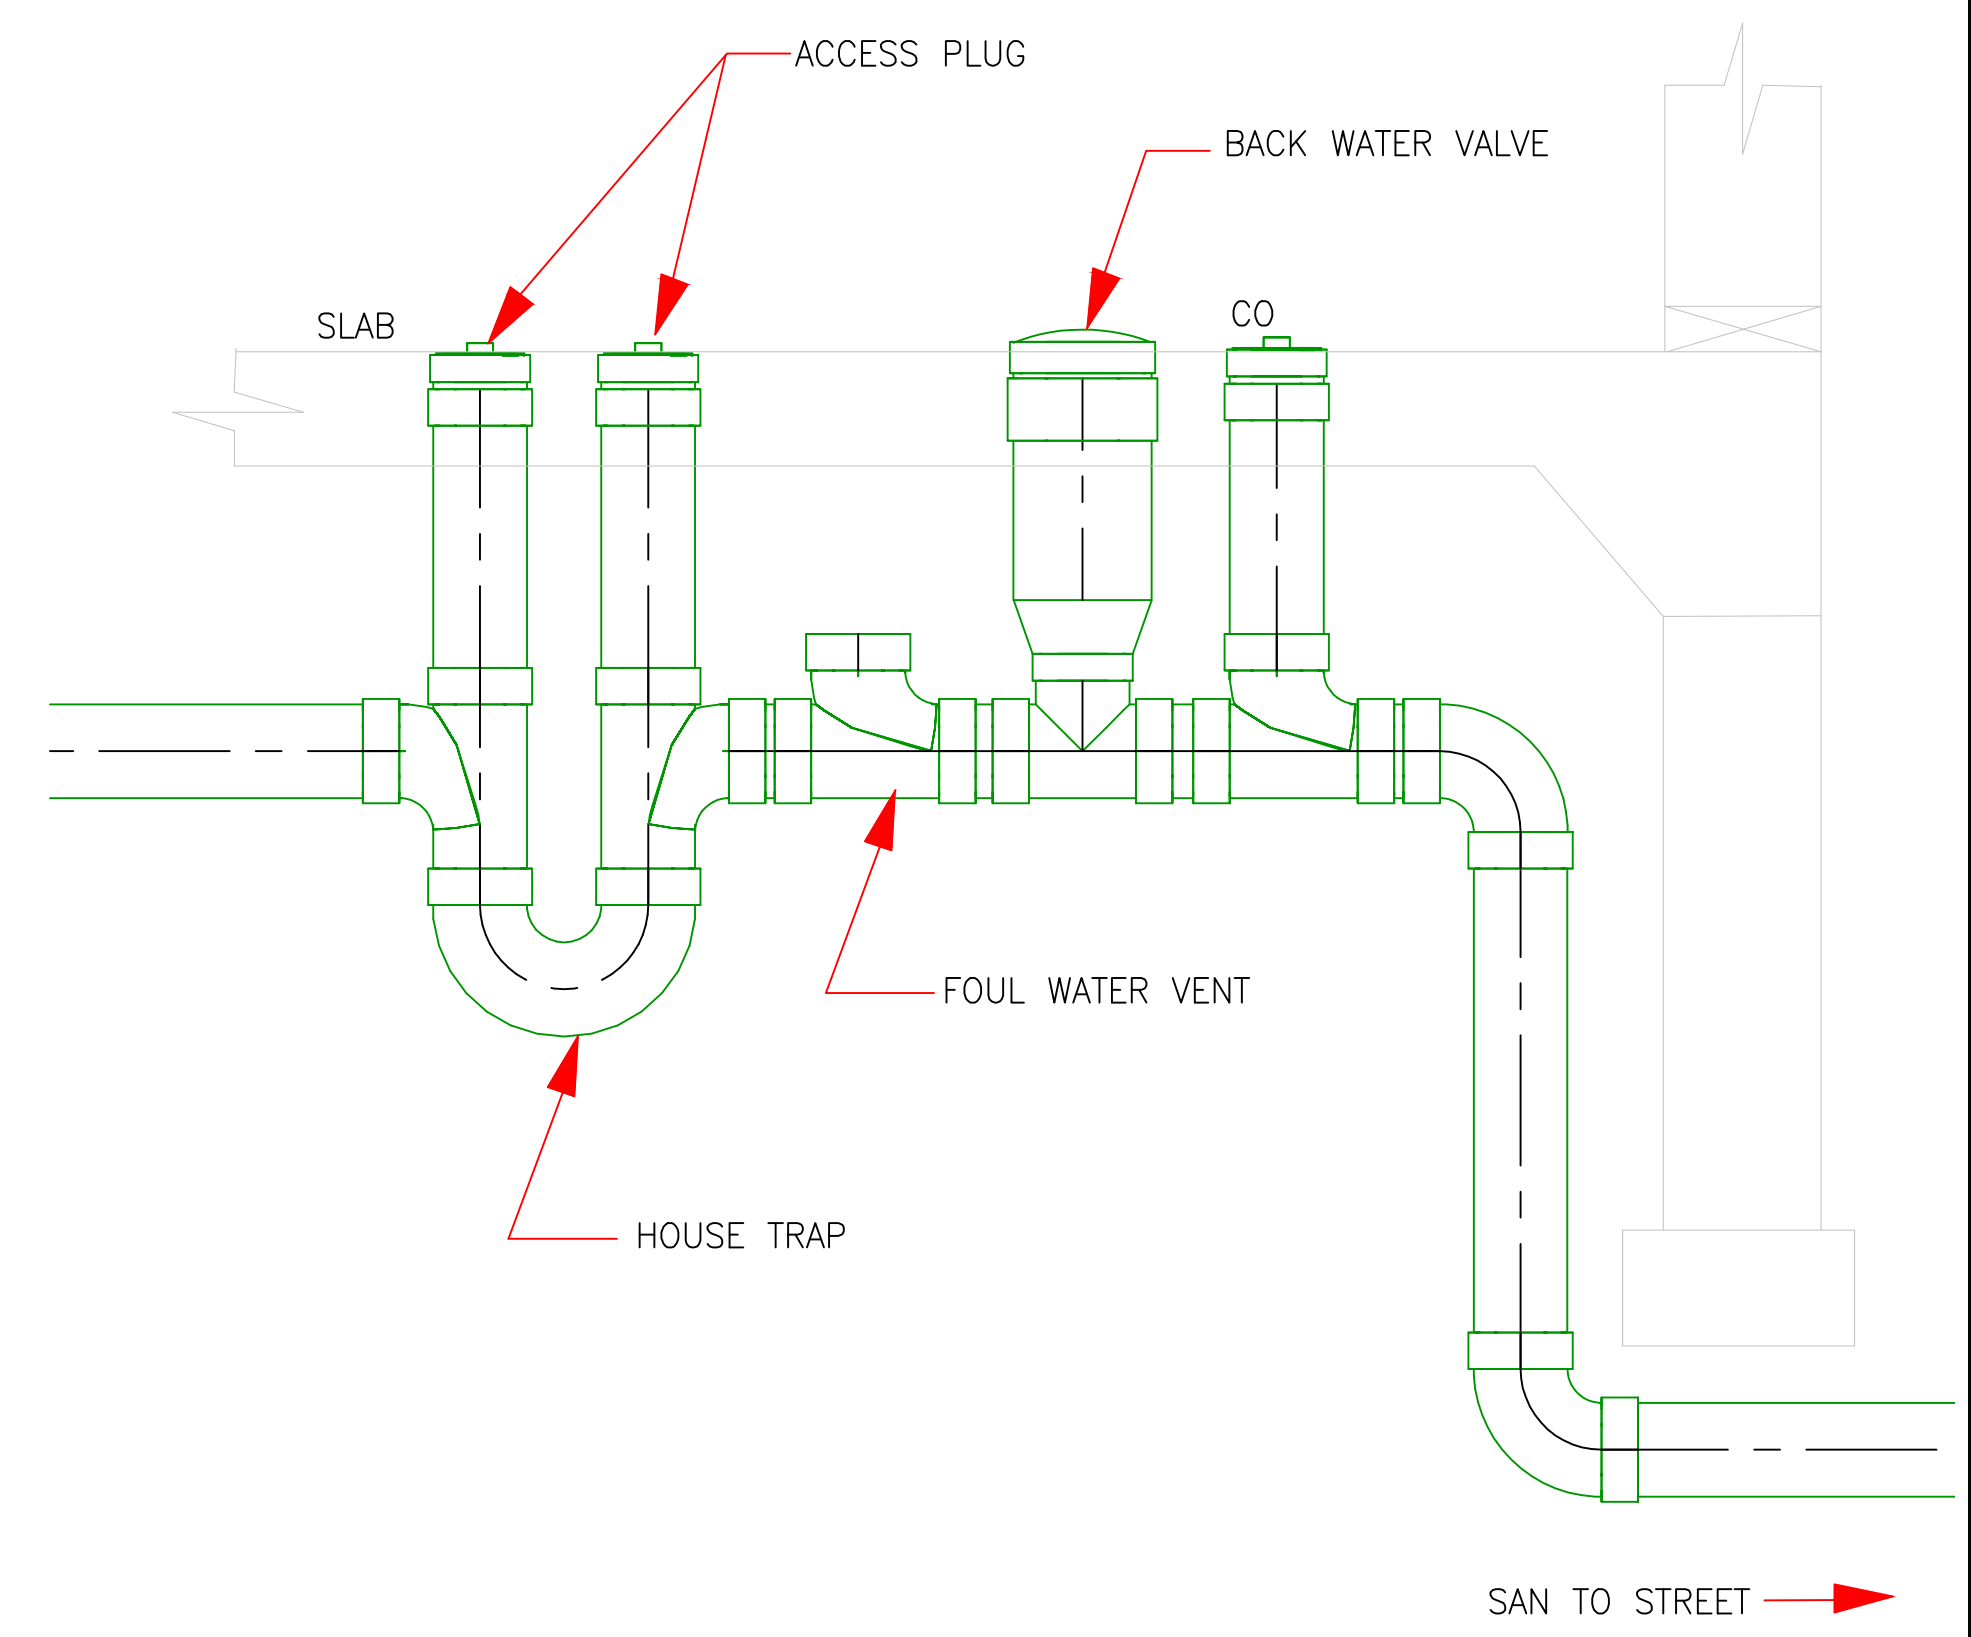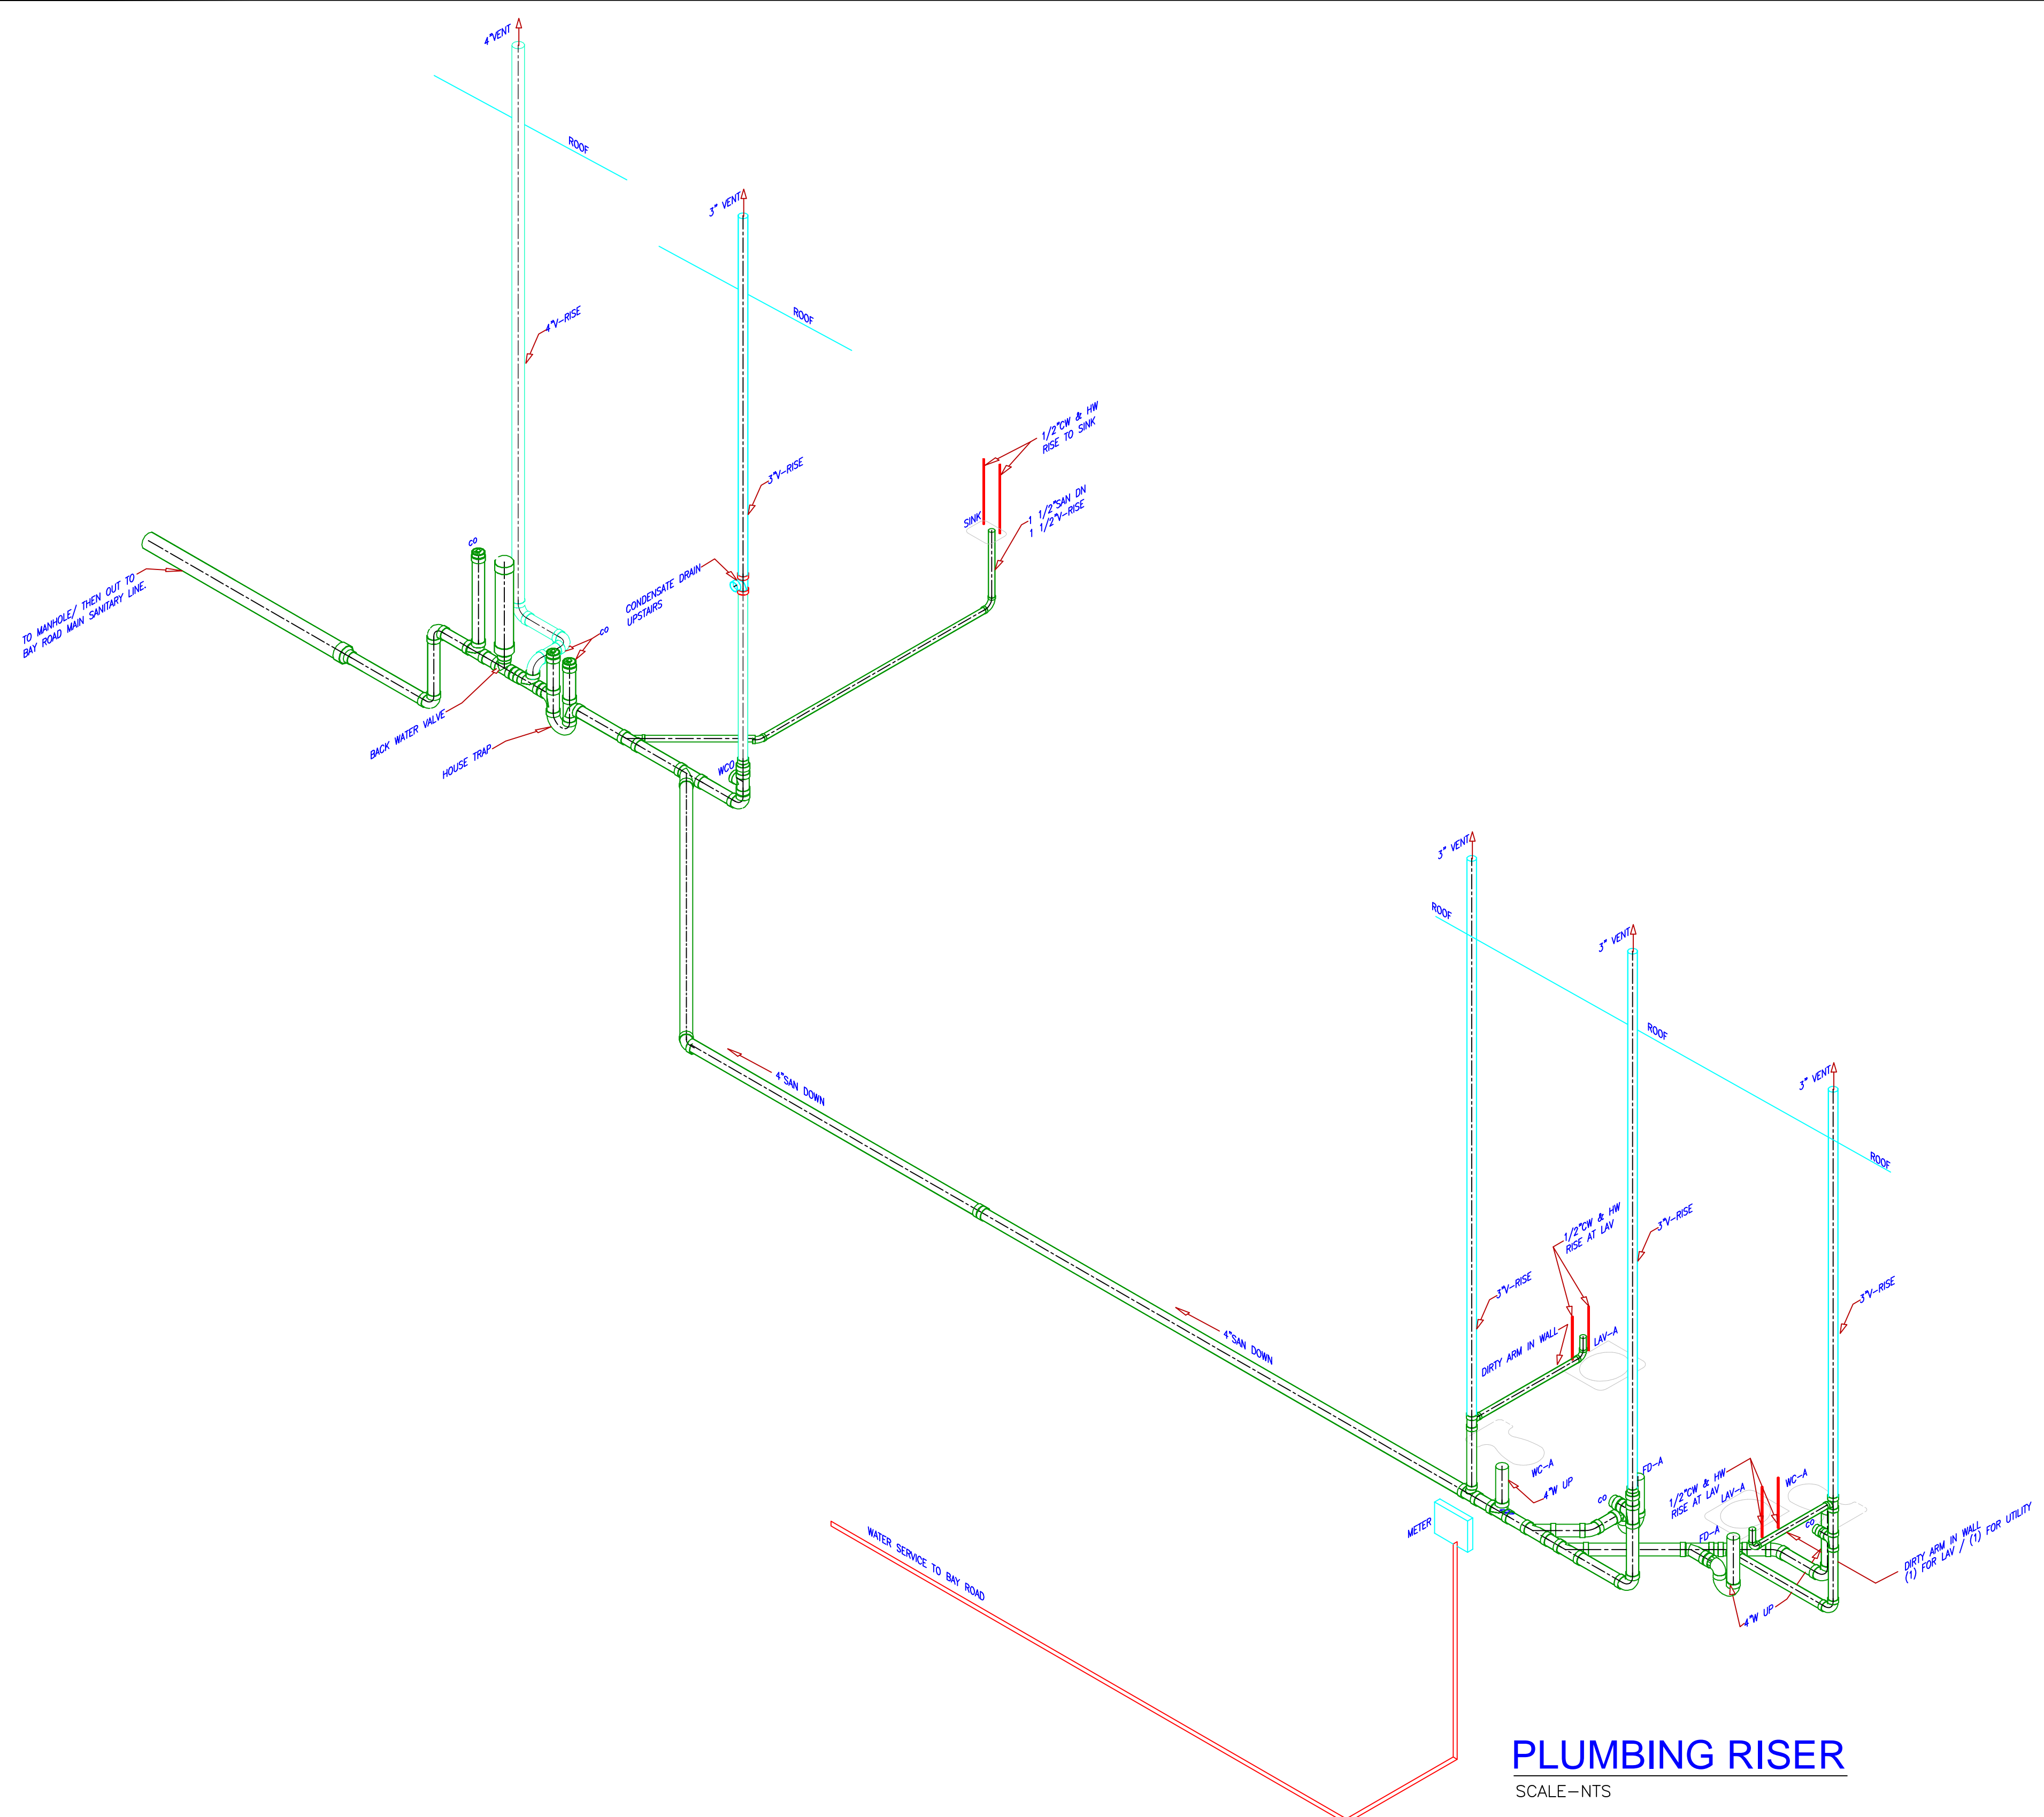

PLUMBING RISER
SCALE-NTS

HOUSE TRAP DETAIL
SCALE-NTS

NOTES	1. -	LEGEND
	2. -	
	3. -	
	4. -	
	5. -	

PROFESSIONAL ENGINEER STAMP:

CLIENT:

TOLERANCES UNLESS NOTED
 DECIMAL ± 0.125"
 FRACTIONAL ± 2"
 ANGULAR ± 5"

ALL DIMENSIONS IN INCHES

THIRD ANGLE PROJECTION USED

PROPRIETARY – The material on this print is proprietary and the property of Advantage Engineering, not to be reproduced, published, or disclosed to others without prior written authorization from Advantage Engineering.

DRAWN	TITLE			
R.A.V.	PLUMBING SE ISOMETRIC & DETAILS			
DATE				
SCALE	SHEET SIZE	DRAWING NO.	SHEET NO.	CHECKED BY
AS SHOWN	D	AB-P103		
		Advantage Engineering P.O. BOX 1042, BALLSTON LAKE, N.Y. 12019		TEL: 518-320-2501 FAX: 518-884-0976 EMAIL: AdvantageEng@nycap.rr.com