

 
REVISIONS			
SYM.	DATE	BY	DESCRIPTION

LEGEND


	SUPPLY DIFFUSER
	RETURN DIFFUSER
	EXHAUST DIFFUSER
	THERMOSTAT
DENOTES THE SERVICE (S=SUPPLY, R=RETURN, E=EXHAUST)	
	AIR FLOW (CFM) DIFFUSER CONNECTION SIZE (IN)
	YORK ROOF TOP UNIT (RTU)

INDEX

COVER PAGES	DESCRIPTION	PAGE NO.
COVER	TITLE PAGE	C-1
INDEX	INDEX & LEGEND	C-2
MECHANICAL	DESCRIPTION	PAGE NO.
HVAC SYSTEM LAYOUT	PLAN OF HVAC UNITS, DUCTWORK, EXHAUST SYSTEMS	M-1
MECHANICAL DETAILS	HVAC DETAILS - ISOMETRIC & SECTIONS	M-2
MECHANICAL SCHEDULE	EQUIPMENT LIST & SPECIFICATIONS	M-3
EQUIPMENT DETAILS	MISCELLANEOUS EQUIPMENT INFORMATION	M-4

	PROFESSIONAL ENGINEER STAMP:		CLIENT:	TOLERANCES UNLESS NOTED DECIMAL ± 0.125" FRACTIONAL ± 2" ANGULAR ± 5"	DRAWN	TITLE				
				ALL DIMENSIONS IN INCHES	R.A.V.	INDEX & LEGEND				
				THIRD ANGLE PROJECTION USED 	DATE					
				PROPRIETARY — The material on this print is proprietary and the property of Advantage Engineering, not to be reproduced, published, or disclosed to others without prior written authorization from Advantage Engineering.						
						SCALE	SHEET SIZE	DRAWING NO.	SHEET NO.	CHECKED BY
						NTS	D	C-2		
							Advantage Engineering P.O. BOX 1042, BALLSTON LAKE, N.Y. 12019			
						TEL: 518-320-2501 FAX: 518-884-0976 EMAIL: AdvantageEng@nycap.rr.com				

REVISIONS			
SYM.	DATE	BY	DESCRIPTION

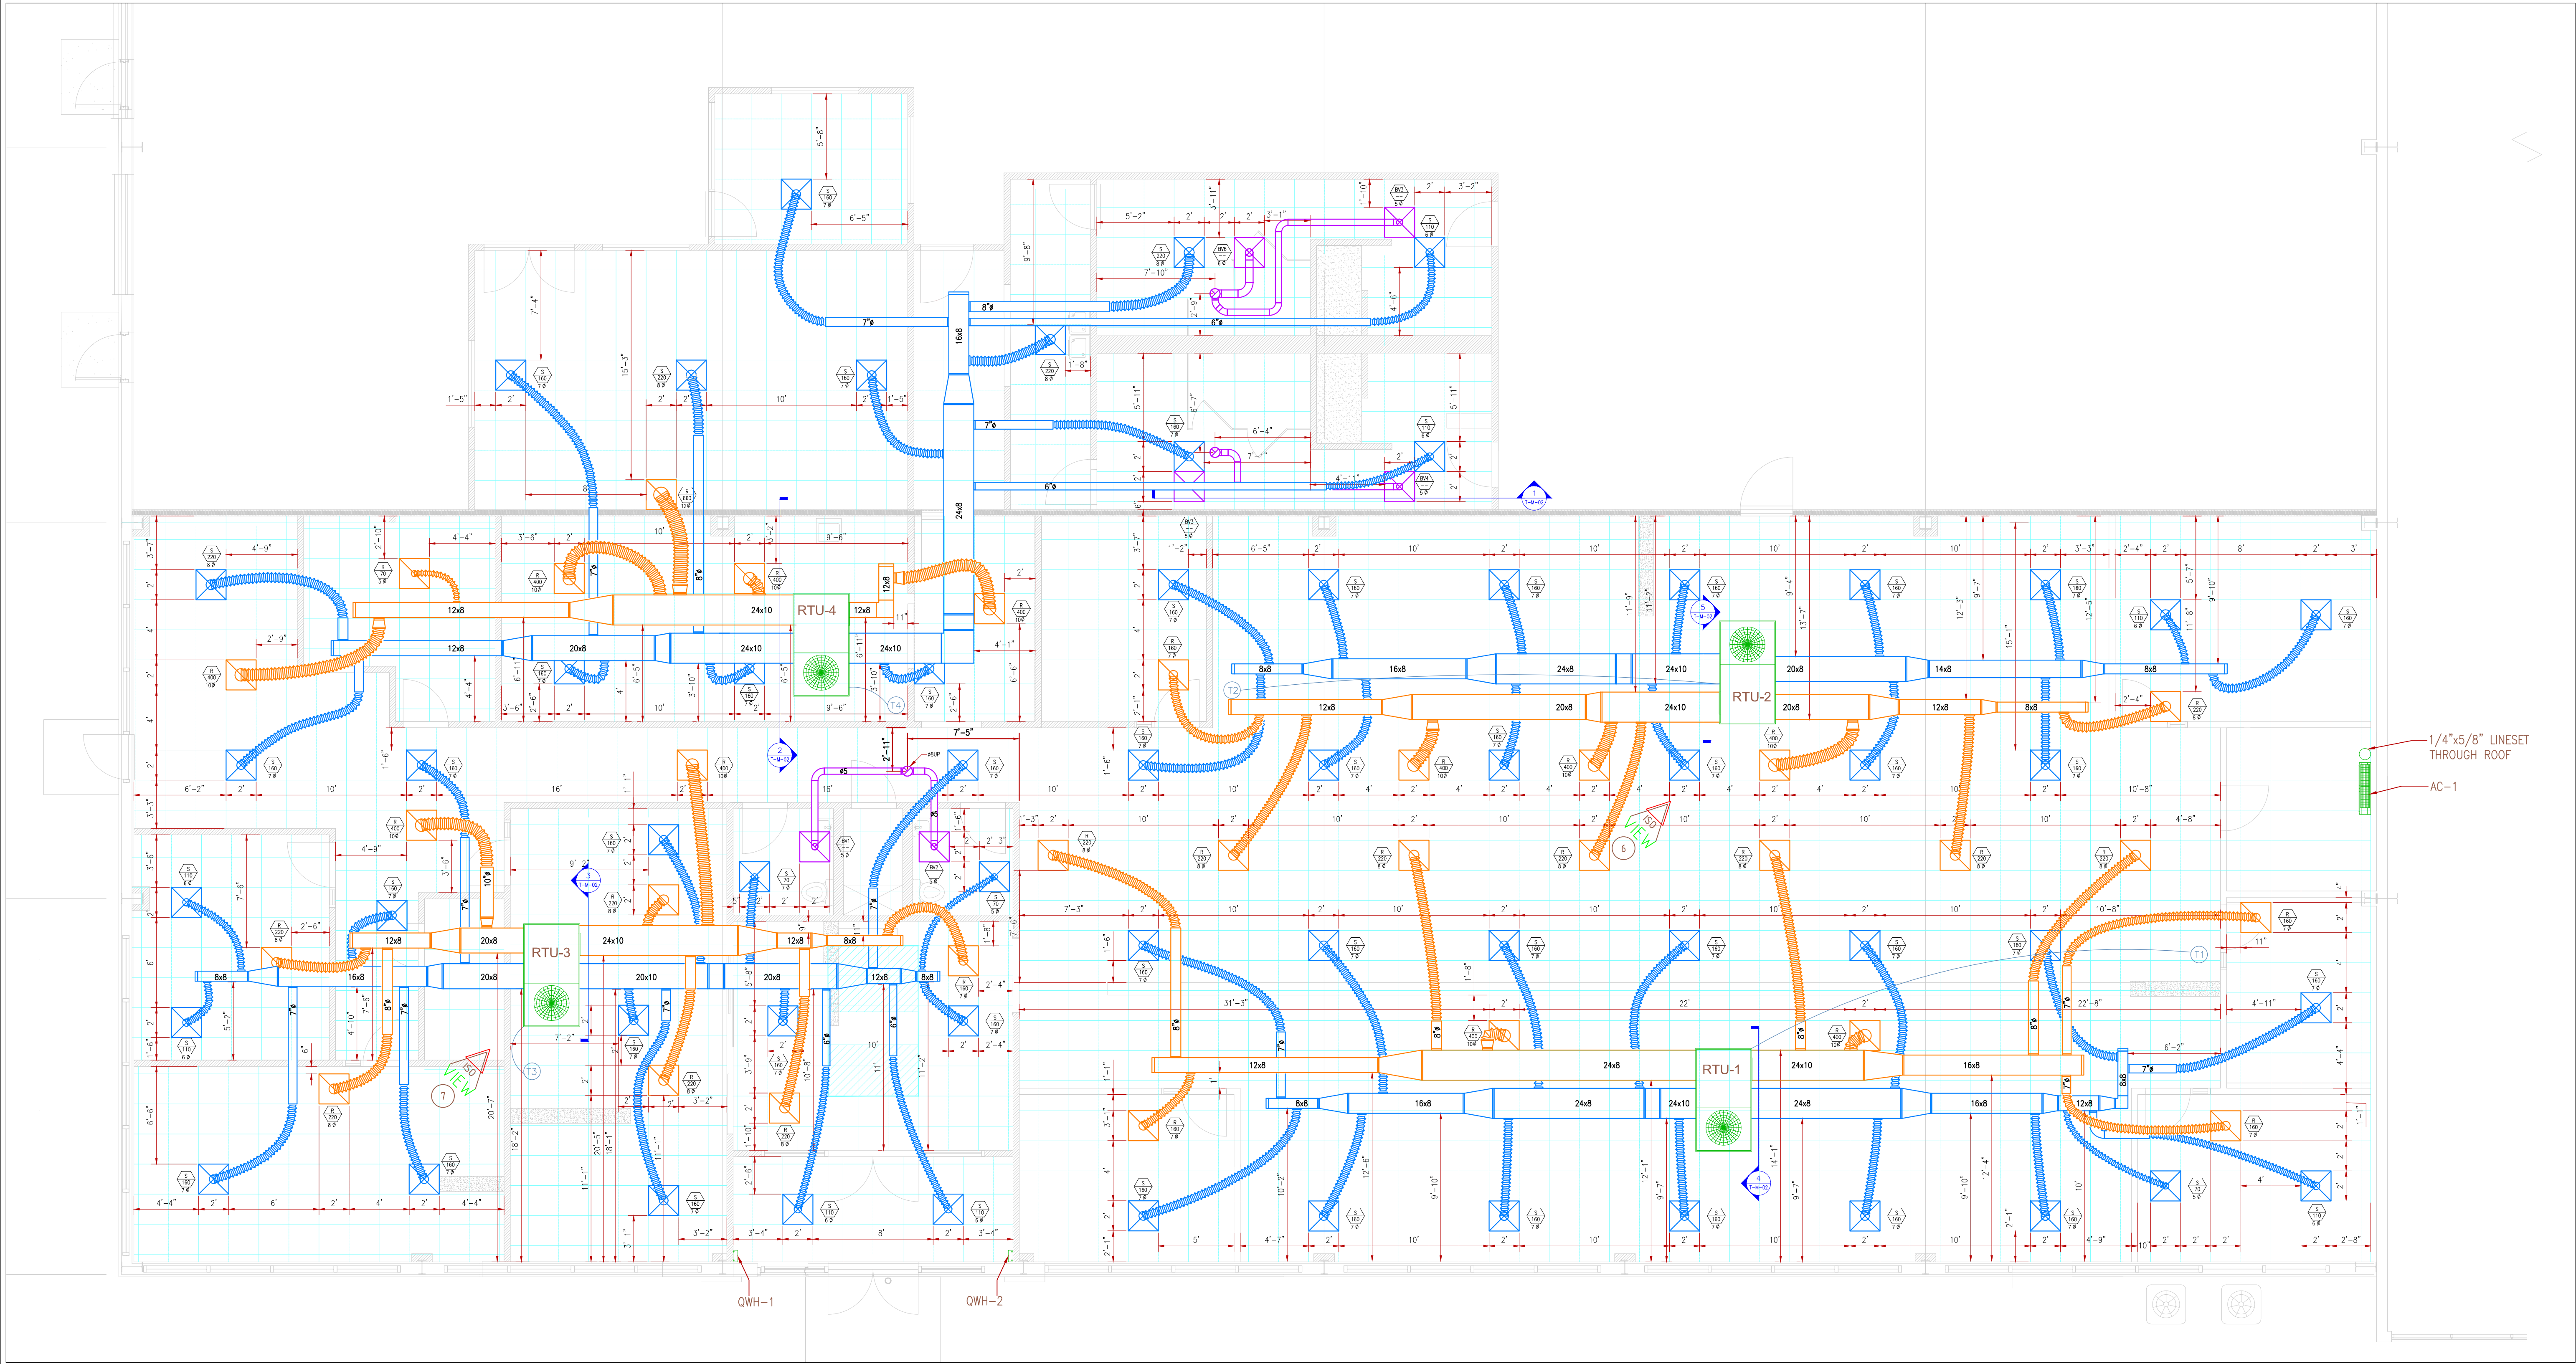

LEGEND

- SUPPLY DIFFUSER
- RETURN DIFFUSER
- EXHAUST DIFFUSER
- THERMOSTAT
- DENOTES THE SERVICE
(S=SUPPLY, R=RETURN, E=EXHAUST)
- AIR FLOW (CFM)
- DIFFUSER CONNECTION SIZE (IN)

PROFESSIONAL ENGINEER STAMP:



CLIENT:

TOLERANCES UNLESS NOTED
DECIMAL $\pm 0.125"$
FRACTIONAL $\pm 2"$
ANGULAR $\pm 5"$

ALL DIMENSIONS IN INCHES

THIRD ANGLE PROJECTION USED

PROPRIETARY – The material on this print is proprietary and the property of Advantage Engineering, not to be reproduced, published, or disclosed to others without prior written authorization from Advantage Engineering.

DRAWN

R.A.V.

DATE

SCALE

1/4"=1'

TITLE

HVAC SYSTEM LAYOUT

SHEET SIZE

D

DRAWING NO.

M-1

SHEET NO.


CHECKED BY




Advantage Engineering
P.O. BOX 1042, BALLSTON LAKE, N.Y. 12019

TEL: 518-320-2501
FAX: 518-884-0976
EMAIL: AdvantageEng@nycaprr.com


REVISIONS			
SYM.	DATE	BY	DESCRIPTION

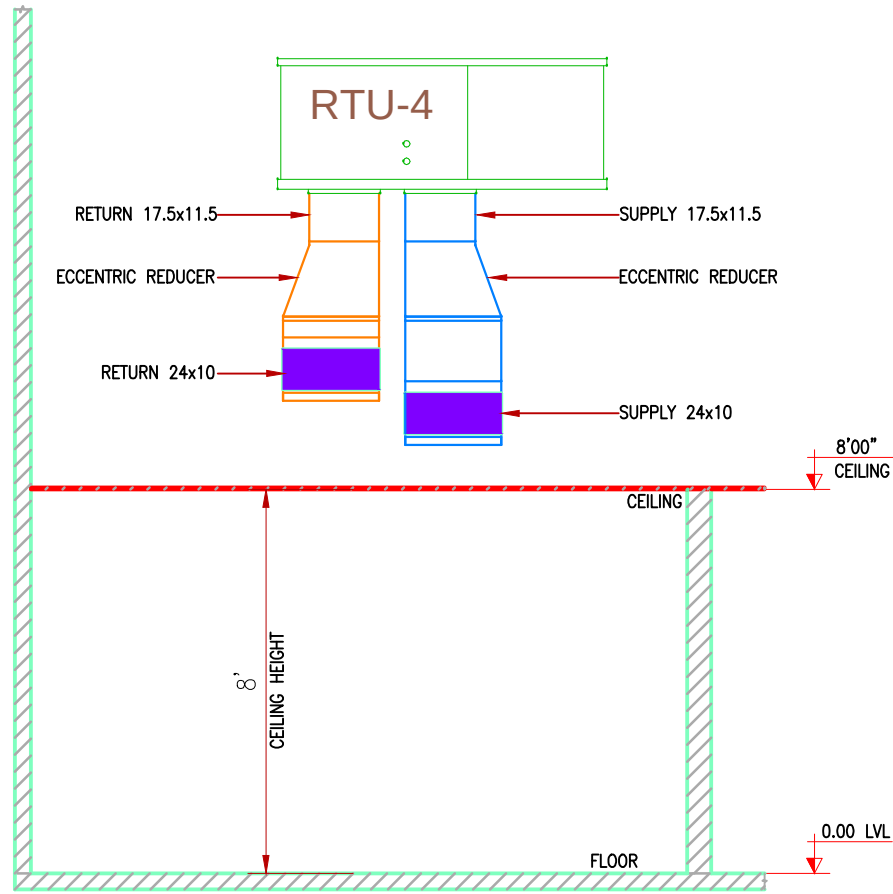


2 SECTION
SCALE: 1/4" = 1'

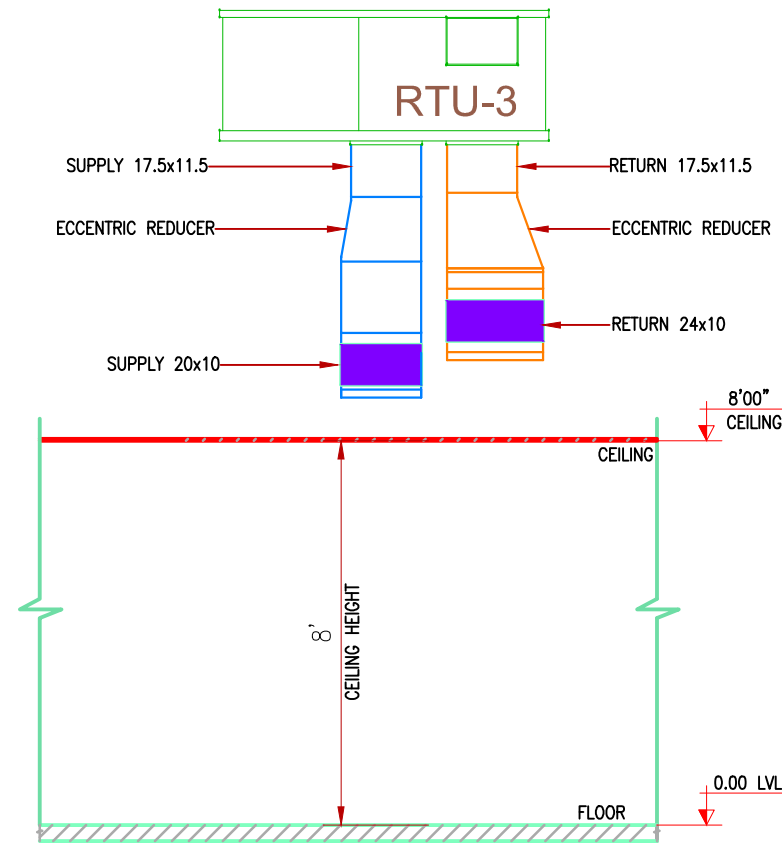


3 SECTION
SCALE: 1/4" = 1'

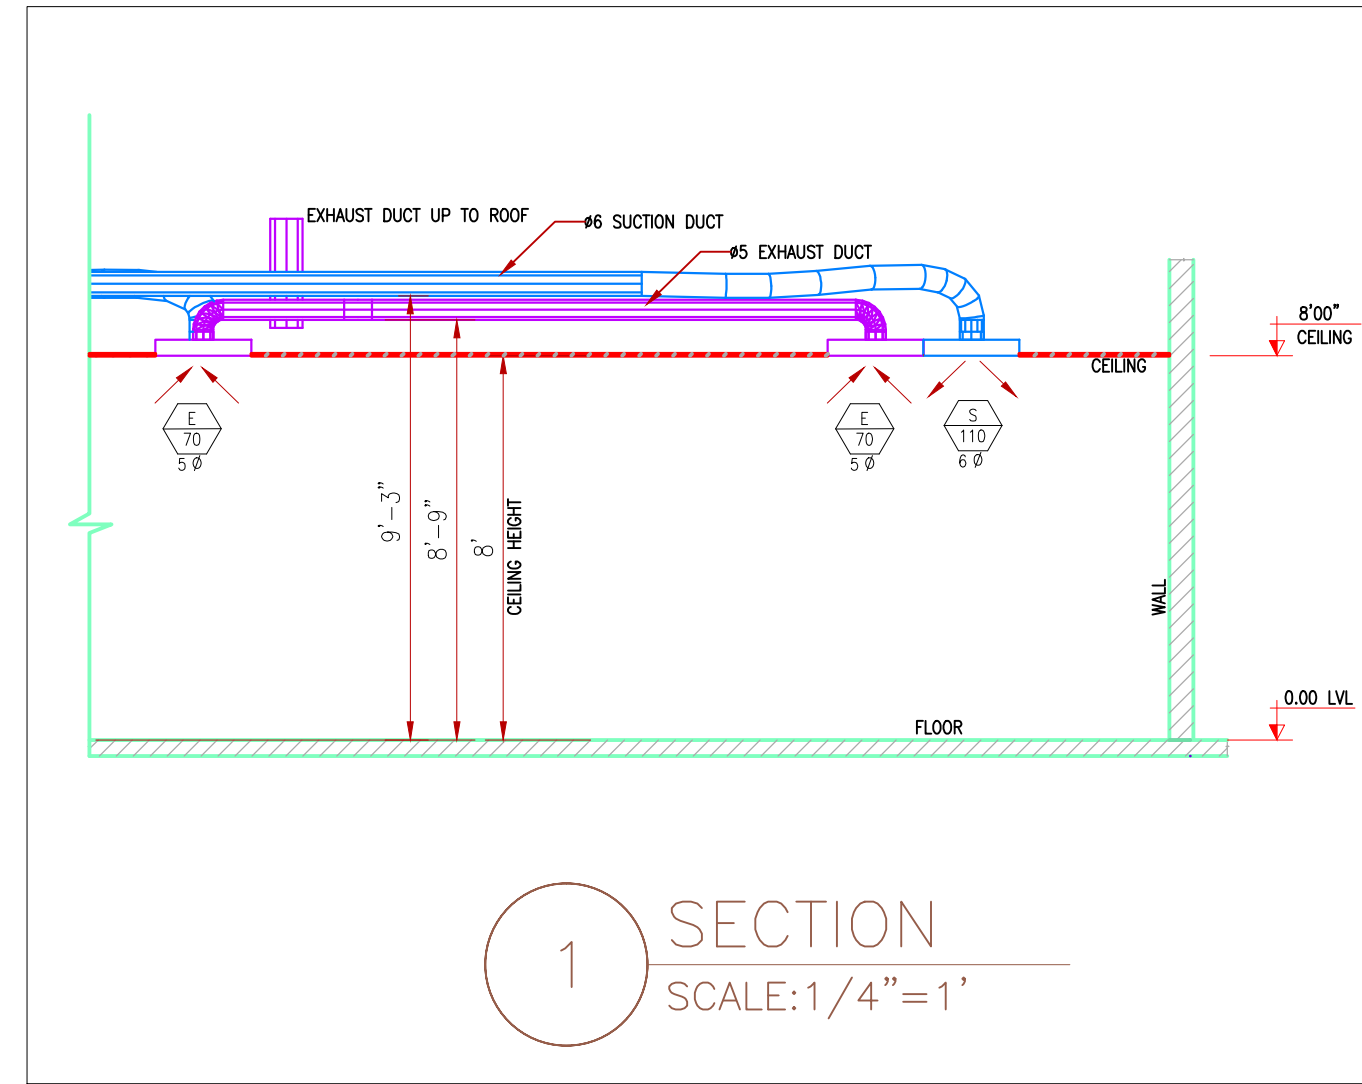


1 SECTION
SCALE: 1/4" = 1'

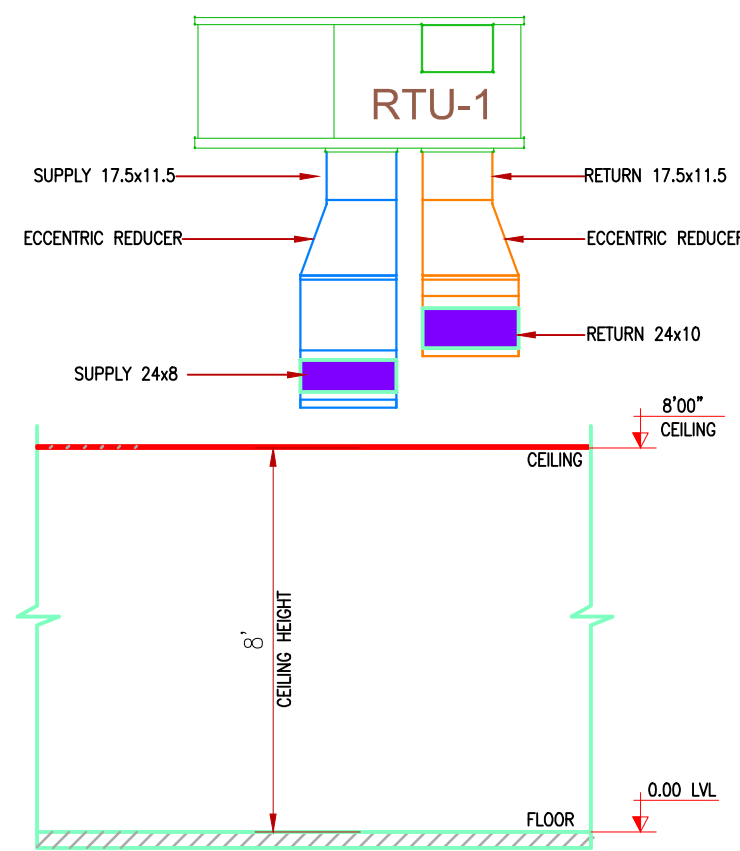


4 SECTION
SCALE: 1/4" = 1'

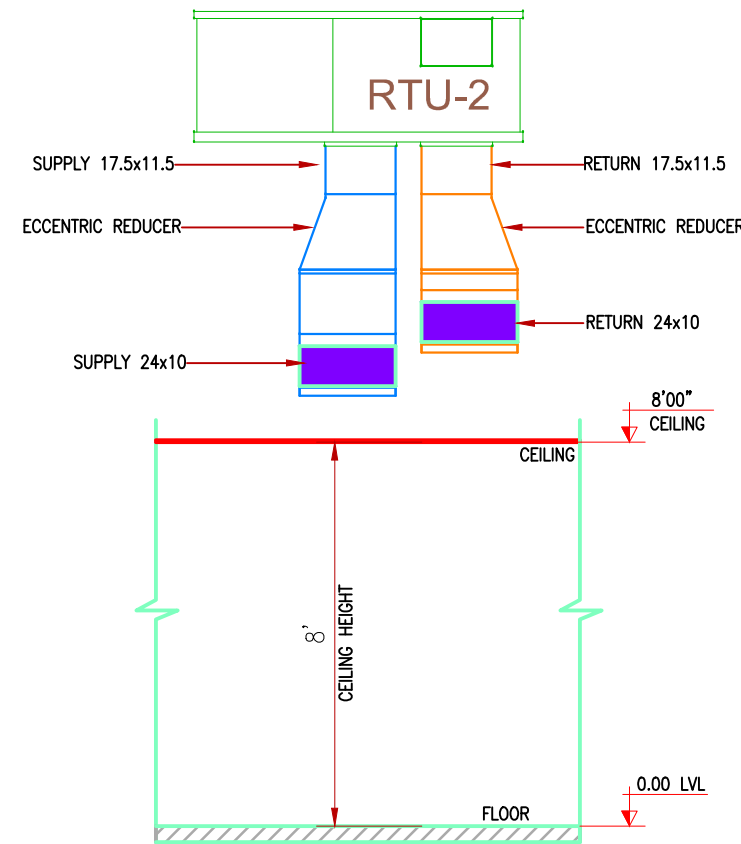


5 SECTION
SCALE: 1/4" = 1'

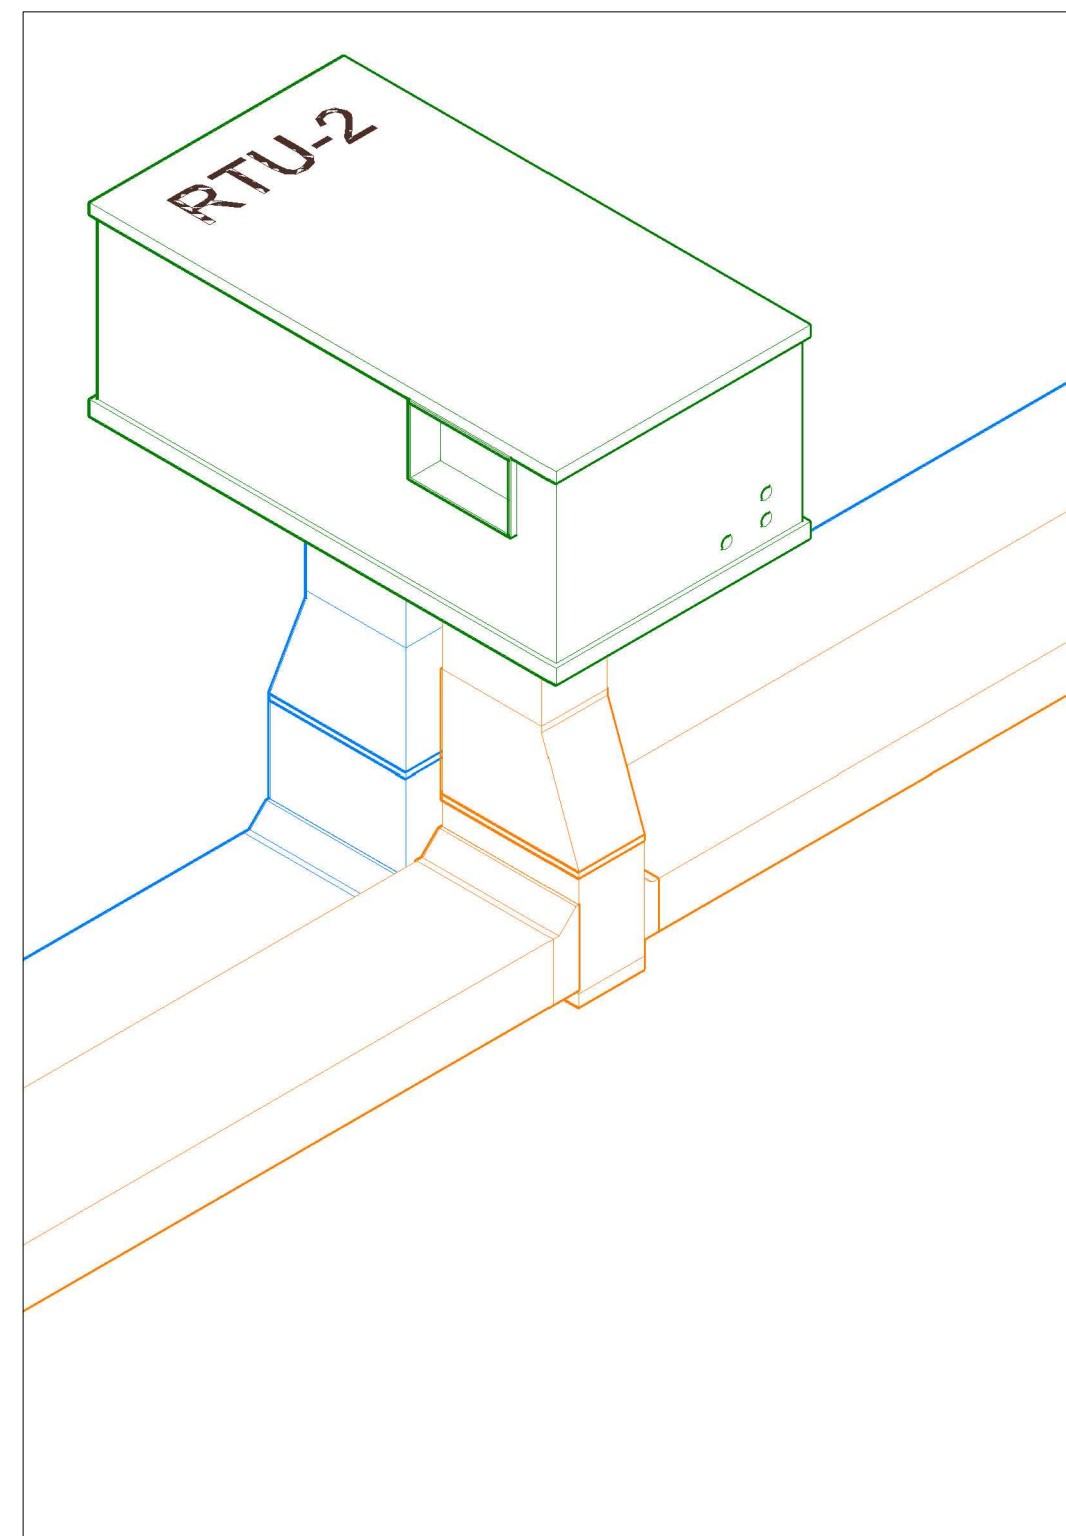

6 ISOMETRIC_VIEW
SCALE: 1/2" = 1'

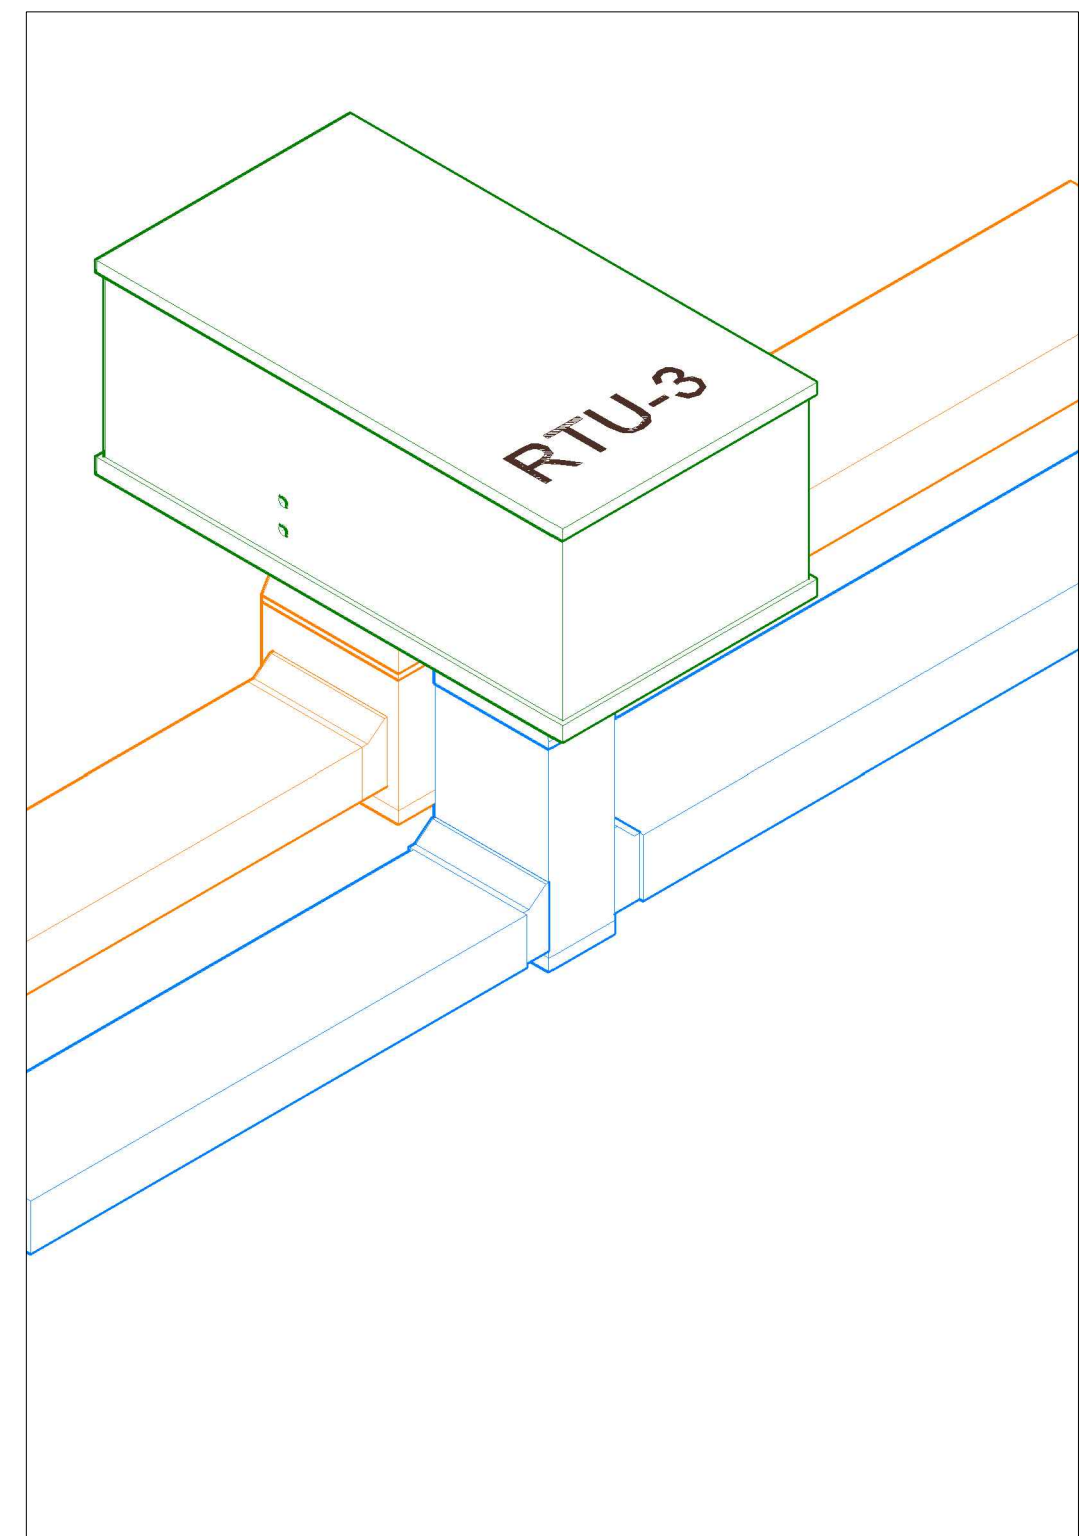

7 ISOMETRIC_VIEW
SCALE: 1/2" = 1'

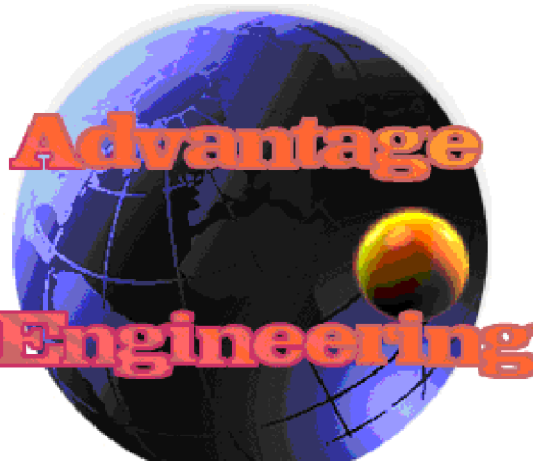NOTES	1. -	PROFESSIONAL ENGINEER STAMP:		CLIENT:	TOLERANCES UNLESS NOTED DECIMAL ± 0.125" FRACTIONAL ± 2" ANGULAR ± 5'		DRAWN	TITLE					
	2. -				ALL DIMENSIONS IN INCHES		R.A.V.	HVAC ISOMETRICS/SECTIONS					
	3. -				THIRD ANGLE PROJECTION USED 		DATE						
	4. -				PROPRIETARY – The material on this print is proprietary and the property of Advantage Engineering, not to be reproduced, published, or disclosed to others without prior written authorization from Advantage Engineering.		SCALE						
	5. -						AS SHOWN	SHEET SIZE		DRAWING NO.	SHEET NO.	CHECKED BY	
							D		M-2				
									 <i>Advantage Engineering</i> P.O. BOX 1042, BALLSTON LAKE, N.Y. 12019				
									TEL: 518-320-2501 FAX: 518-884-0976 EMAIL: AdvantageEng@nycap.rr.com				

												REVISIONS			
SYM.		DATE		BY		DESCRIPTION									

ROOFTOP AIR CONDITIONING AND HEATING UNIT												
UNIT NO.	LOCATION	AREAS SERVED	MANUFACTURER	MODEL	COOLING					HEATING		COMMENTS
					TONS	ELEC	MCA	REF	EER	BTUH	EFF	
RTU-1	ROOF	111/112/113/116	YORK	DJ060N10P2AAA3	5	208-230/3/60	34.0	R-22	11	100,000	80%	
RTU-2	ROOF	115/116/117	YORK	DJ060N10P2AAA3	5	208-230/3/60	34.0	R-22	11	100,000	80%	
RTU-3	ROOF	100/101/102/103/104/104/108/109/110	YORK	DJ060N10P2AAA3	5	208-230/3/60	34.0	R-22	11	100,000	80%	
RTU-4	ROOF	106/107/118/122/120/120a/121/121a/123/124	YORK	DJ060N10P2AAA3	5	208-230/3/60	34.0	R-22	11	100,000	80%	

EXHAUST FAN SCHEDULE										
UNIT NO.	LOCATION	COLUMN LINES	MANUFACTURER	MODEL	SIZE	PERFORMANCE				COMMENTS
						CFM	S.P.	VOLT	AMPS	
BV-1	MEN'S ROOM - 108	F-1	BROAN	QTR080	5"	80	0.1	115/1	0.7	
BV-2	WOMEN'S ROOM - 110	F-1	BROAN	QTR080	5"	80	0.1	115/1	0.7	
BV-3	WOMEN'S ROOM - 120	E-2	BROAN	QTR080	5"	80	0.1	115/1	0.7	
BV-4	WOMEN'S LOCKERS - 120a	E-2	BROAN	QTR080	5"	80	0.1	115/1	0.7	
BV-5	MEN'S LOCKERS - 120a	D-2	BROAN	QTR080	5"	80	0.1	115/1	0.7	
BV-6	MEN'S ROOM - 121	D-2	BROAN	QTR080	5"	80	0.1	115/1	0.7	

HEATING / COOLING SPLIT UNIT											
UNIT NO.	PRIMARY AREAS SERVED	MANUFACTURER	MODEL	COOLING BTUH	SEER	HEATING BTUH	HSPF	ELEC	MCA	COMMENTS	
AC-1	ELECTRIC ROOM 114	DAIKIN	FTXS24DVJU RXS24DVJU	22,000	15	24,000	9.2	208/230/1/60	15.8		

WALL HEATER SCHEDULE								
UNIT NO.	LOCATION	MANUFACTURER	MODEL	BTUH	ELECTRICAL			COMMENTS
					VOLT	AMPS	WATTS	
QWH-1	VESTIBULE	QMARK	CWH1202DS	6836 / 3413	240	8.4 / 4.2	2000/1000	HIGH/LOW SETTINGS

NOTES

1. -

2. -

3. -

4. -

5. -

 
PROFESSIONAL ENGINEER STAMP:



CLIENT:

TOLERANCES UNLESS NOTED
DECIMAL ± 0.125"
FRACTIONAL ± 2"
ANGULAR ± 5"

ALL DIMENSIONS IN INCHES

THIRD ANGLE PROJECTION USED 

PROPRIETARY – The material on this print is proprietary and the property of Advantage Engineering, not to be reproduced, published, or disclosed to others without prior written authorization from Advantage Engineering.

DRAWN

R.A.V.

DATE

SCALE

NTS



TITLE

EQUIPMENT SCHEDULE

SHEET SIZE

D

DRAWING NO.

M-3

SHEET NO.

CHECKED BY


Advantage Engineering

P.O. BOX 1042, BALLSTON LAKE, N.Y. 12019

TEL: 518-320-2501
FAX: 518-884-0976
EMAIL: AdvantageEng@nycap.rr.com

ROOF TOP UNITS


QMARK WALL HEATERS - COMMERCIAL CHW 1202DS

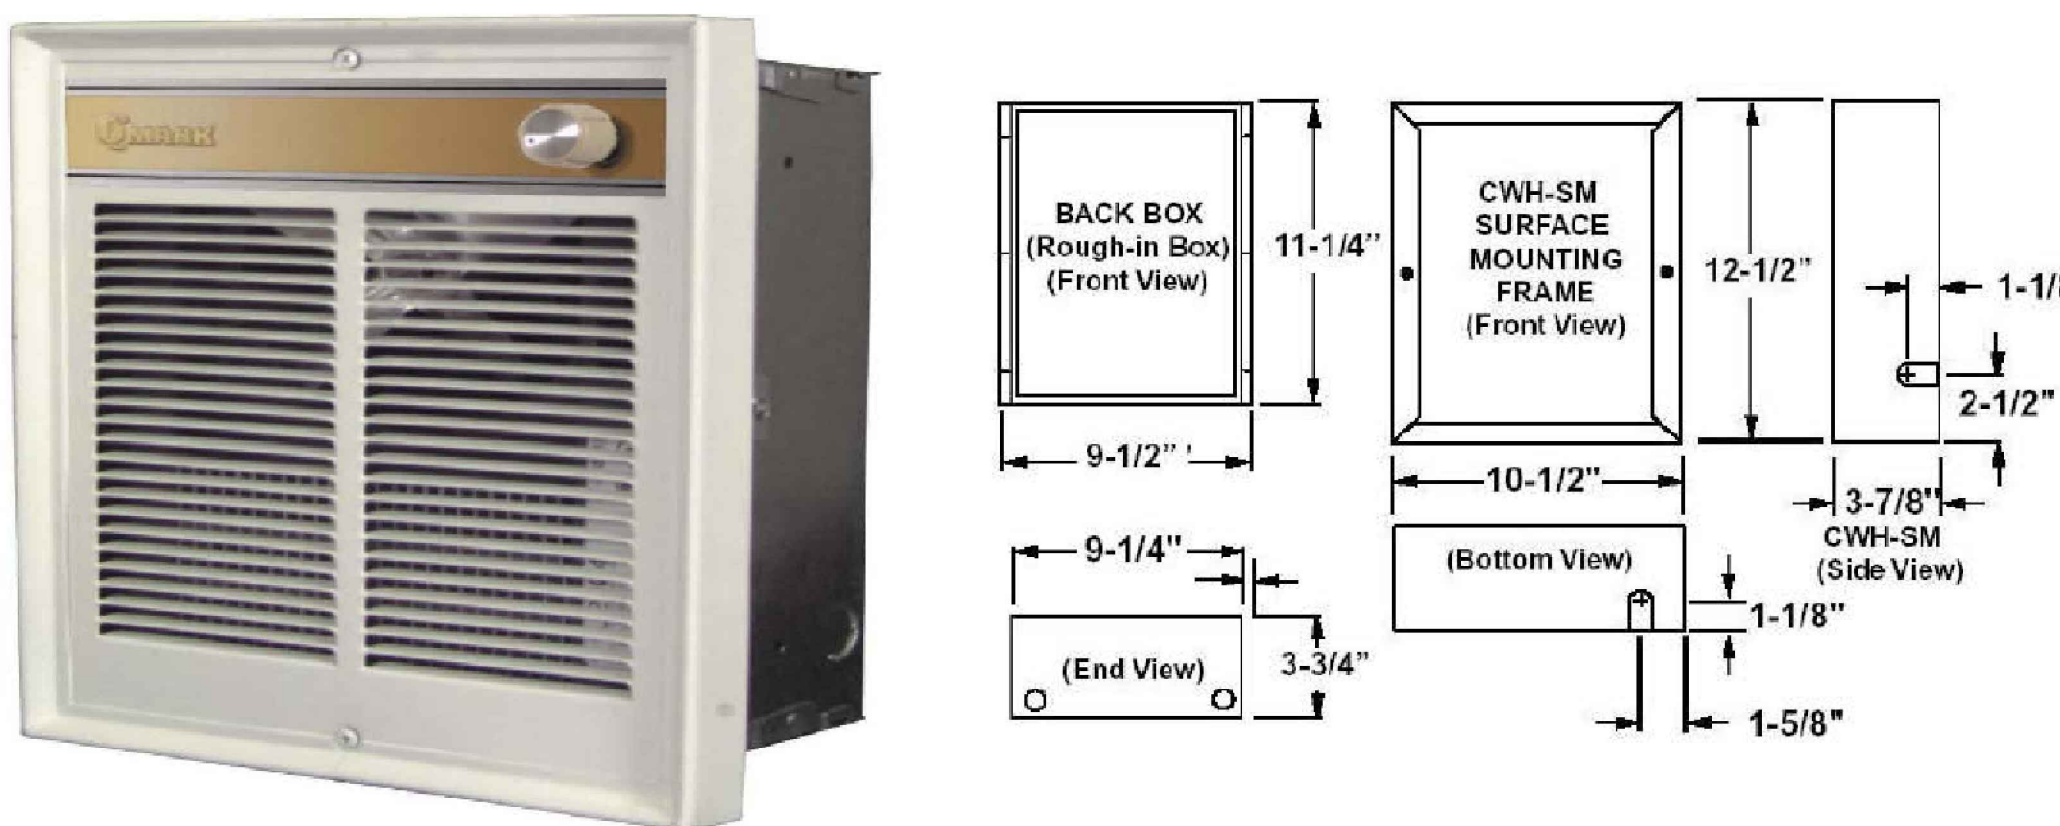

SINGLE SPLIT AC UNITS

The image shows a white Panasonic air conditioning system. At the top is the indoor unit, a long, slim, white rectangular device with the Panasonic logo on the left. Below it to the left is a white remote control with a small color display and several buttons. To the right of the remote is the outdoor unit, a white rectangular box with a large black circular fan grille in the center and the Panasonic logo on the right side.

EXHAUST FANS

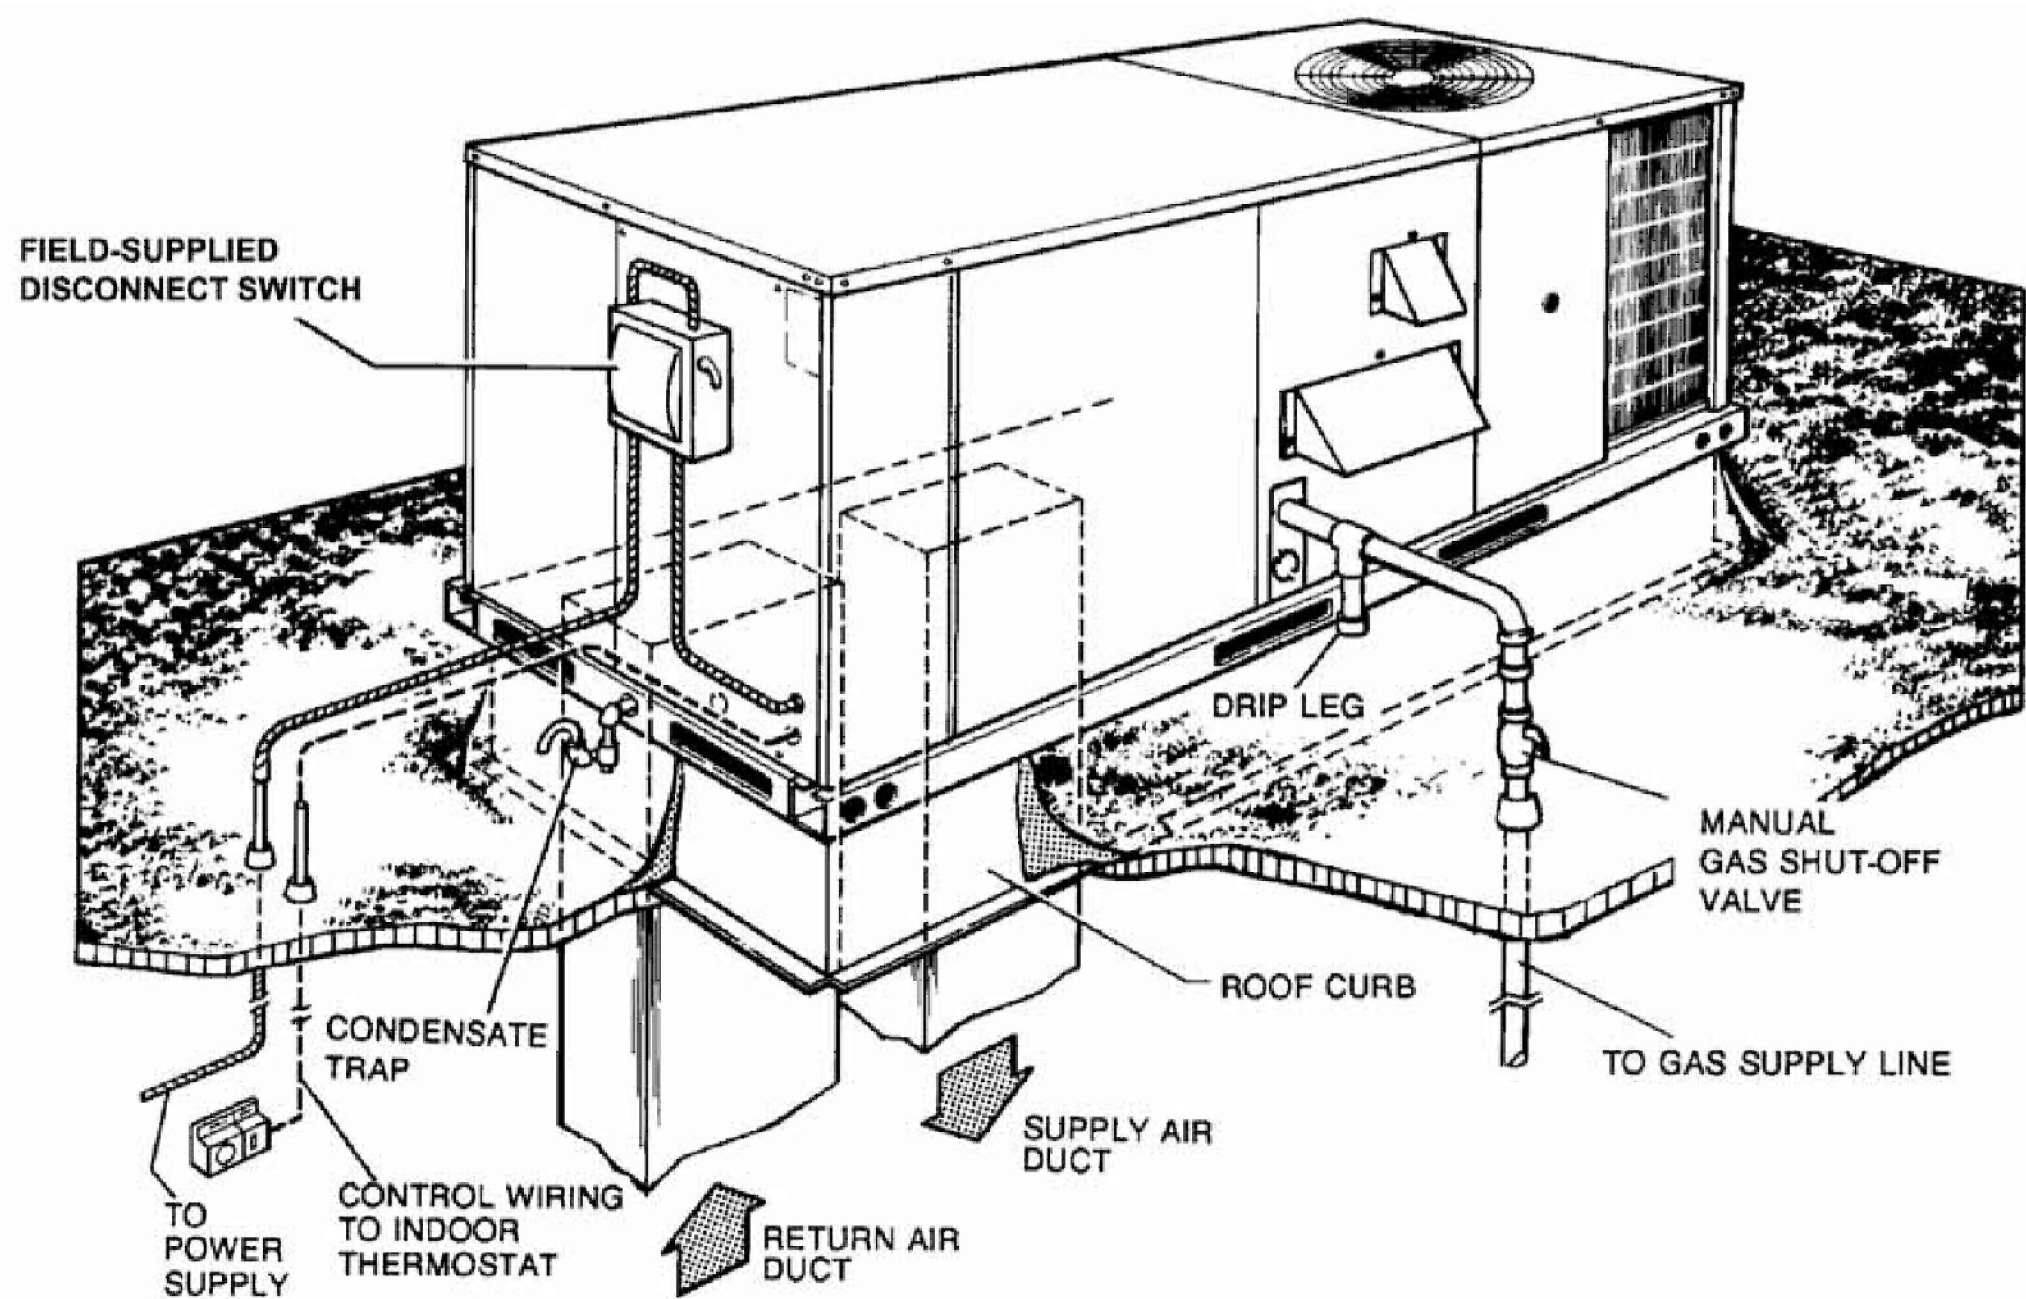

FTXS24DVJU

41-5/16

9-7/16
9-3/8

11-7/16

The drawing shows a front view of the unit on the left and a side view on the right. The front view has a width dimension of 41-5/16. The side view has a height dimension of 11-7/16. To the right of the side view, there are two stacked height dimensions: 9-7/16 and 9-3/8.

RXS24DVJU

Technical drawings of the RXS24DVJU refrigerator. The front view shows a refrigerator with a top freezer and bottom refrigerator compartment, with a width dimension of 13-3/4 inches. The side view shows the refrigerator's profile with a height dimension of 28-1/2 inches, a depth dimension of 32-1/2 inches, and a door swing dimension of 3-1/16 inches.

Standard Features:	
Compressor Warranty	7 years
Parts Warranty	5 years
Limited Labor Warranty	1 year
Remote Control	

Options:
~~Air Purifying Filter with Photocatalytic Deodorizing Function~~
~~Controlled Circulation of Air~~

NOTES	1. -	PROFESSIONAL ENGINEER STAMP:		CLIENT:	TOLERANCES UNLESS NOTED DECIMAL ± 0.125" FRACTIONAL ± 2" ANGULAR ± 5'	DRAWN	TITLE			
	2. -				ALL DIMENSIONS IN INCHES	R.A.V.	HVAC EQUIPMENT DETAILS			
	3. -				THIRD ANGLE PROJECTION USED 	DATE				
	4. -				PROPRIETARY — The material on this print is proprietary and the property of Advantage Engineering, not to be reproduced, published, or disclosed to others without prior written authorization from Advantage Engineering.	SCALE				
	5. -					NTS	D	M-4		
							Advantage Engineering P.O. BOX 1042, BALLSTON LAKE, N.Y. 12019 TEL: 518-320-2501 FAX: 518-884-0976 EMAIL: AdvantageEng@nycap.rr.com			